



# **RAINBOW Villa's**


**4 BHK ULTRA LUXURIOUS BUNGALOW**

**PROMOTER : RAJESHWARI DEVELOPERS**

**ADDRESS :- Rainbow Villa's, Beside Bhagirath South Park,  
Lambha 382405 Ahmedabad**

**For Booking cont .number :- 9714447173**

**PAGE NO.1**

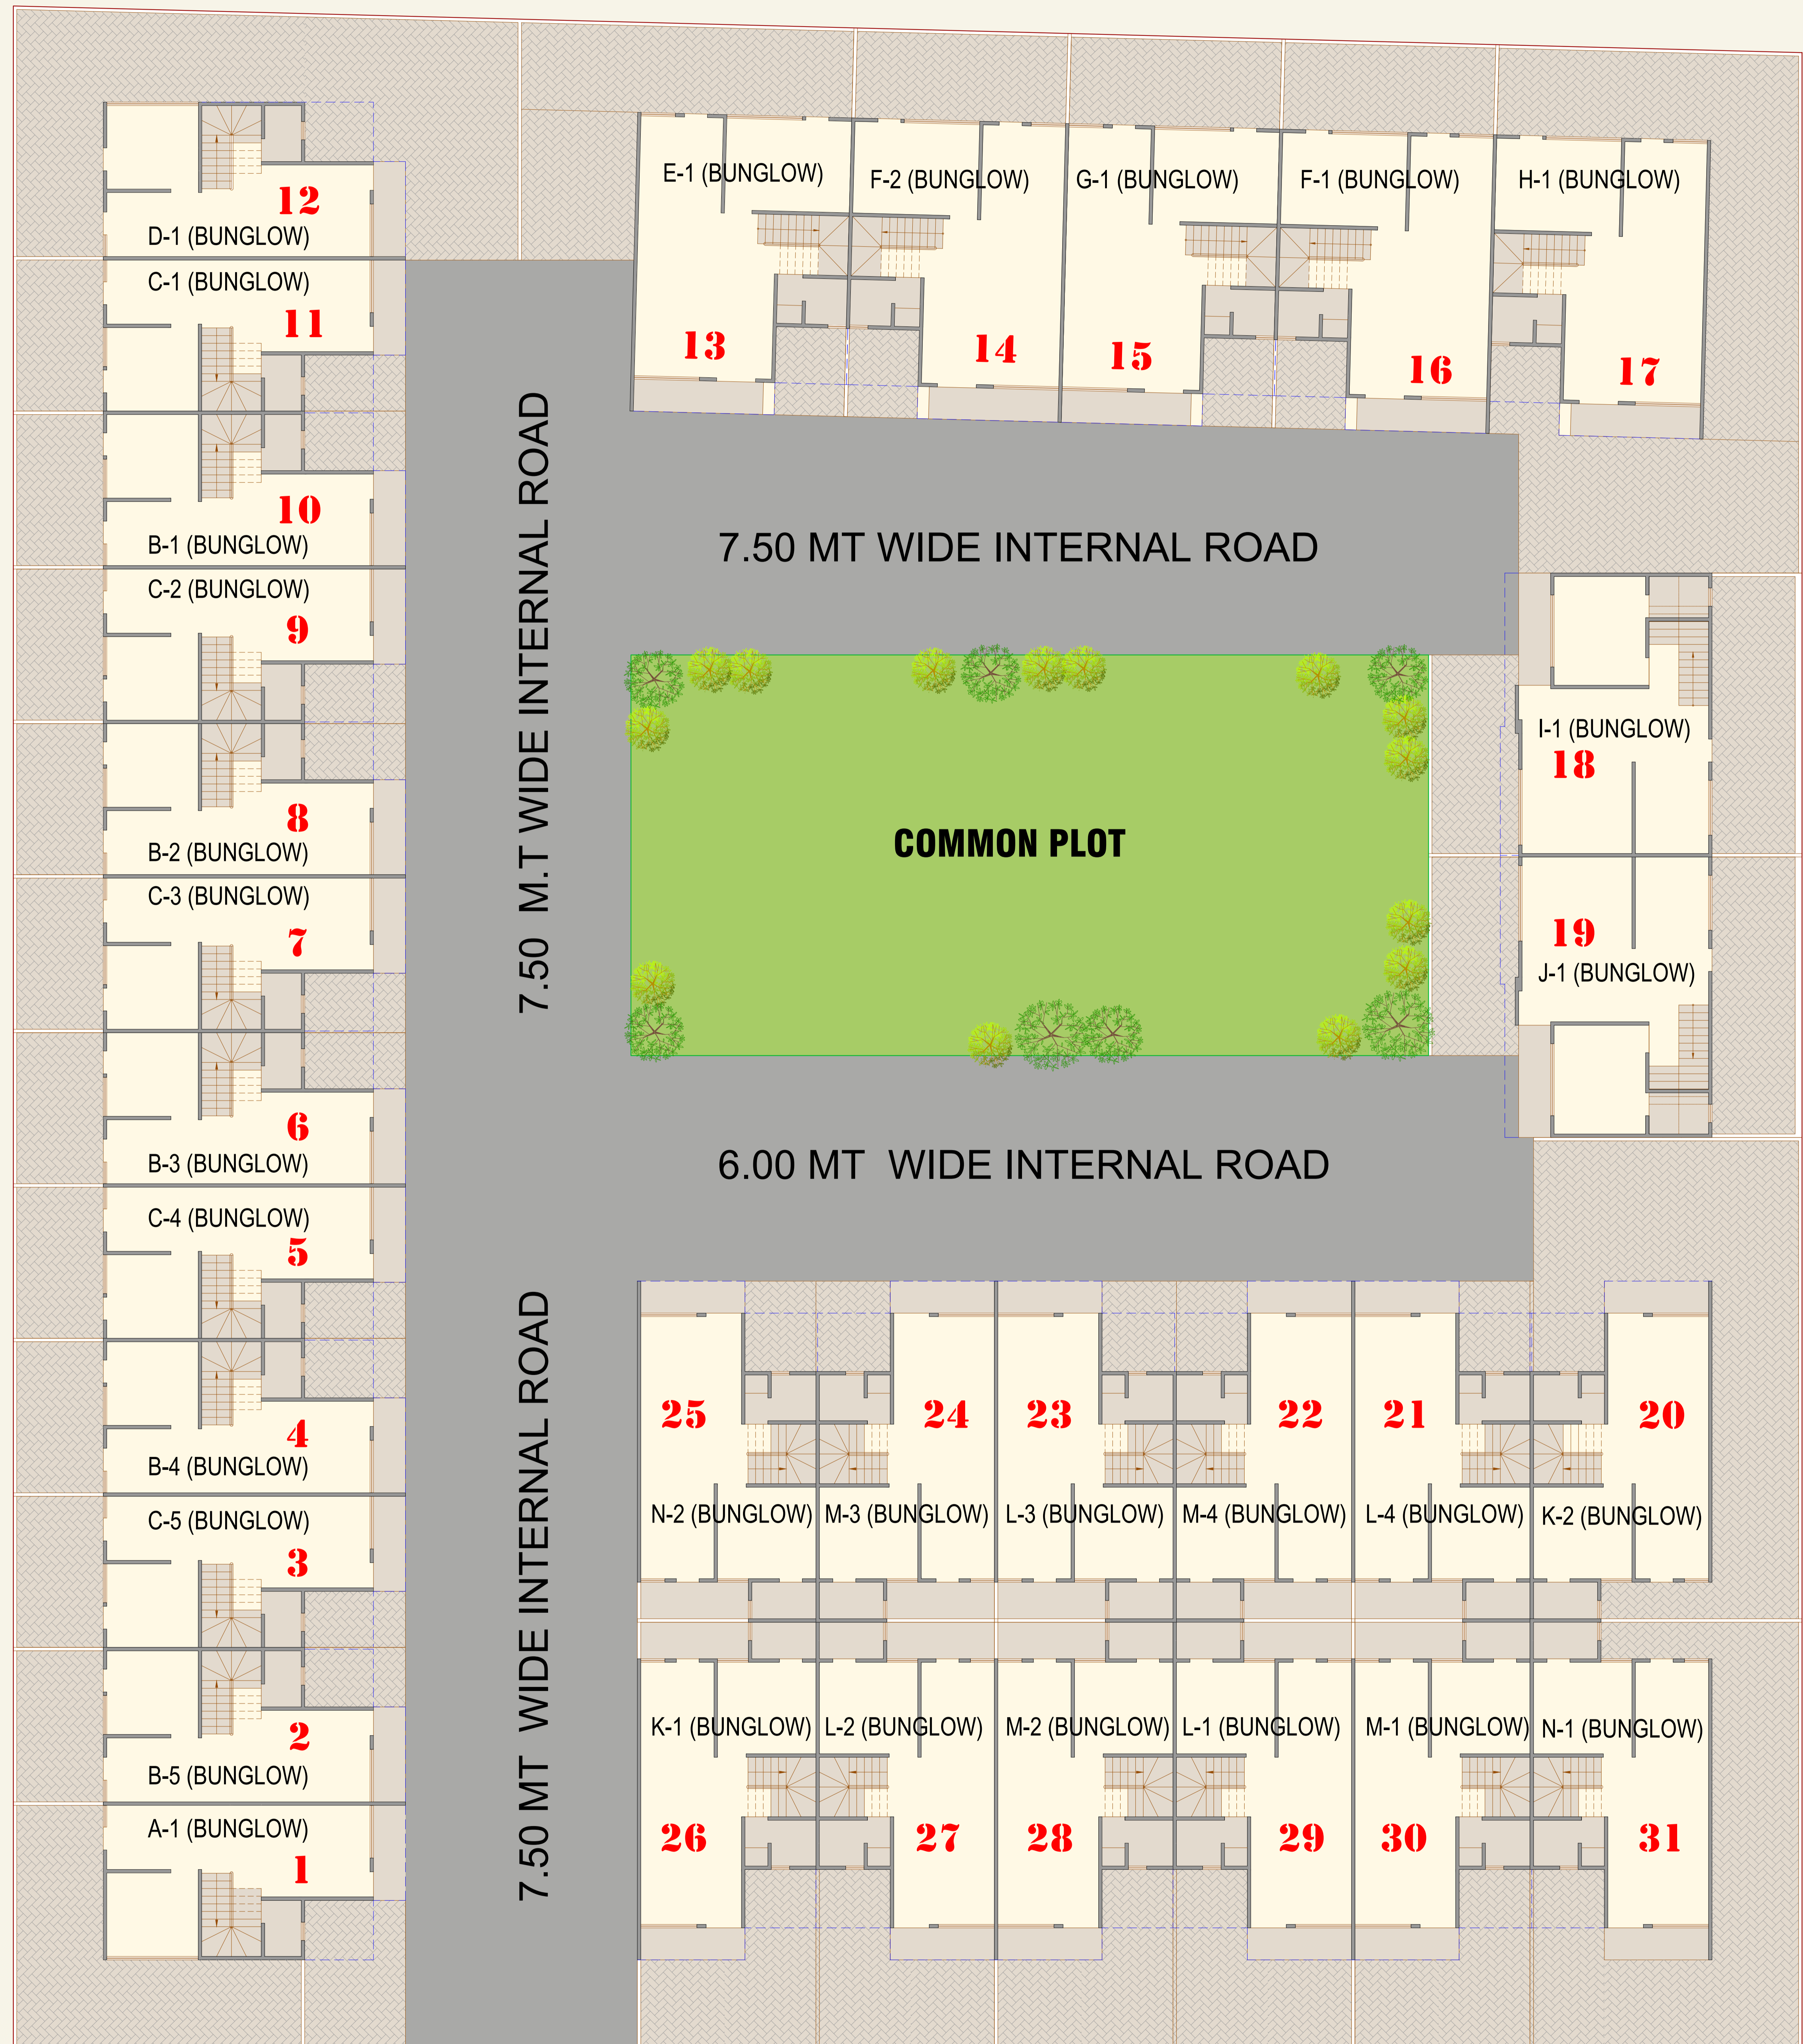


PROJECT NAME : RAINBOW VILLA'S

DRG. TITLE : LAY OUT PLAN

LOCATED

@

NORTH LOCATION

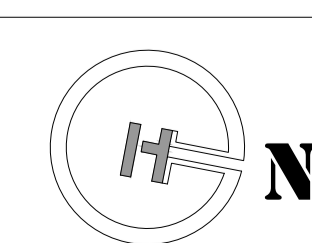

DRG. SCALE

NOT TO SCALE


DATE : 07.01.2023

DRN. BY : ROSHANI


CHK. BY : VIRAL PATEL

**The HAPPY DESIGN**


FF-9, SHRINIVAS COMPLEX,  
OPP. VAIBHAV HALL, GHODASAR,  
AHMEDABAD. 380050  
M : +91 98984 34241  
M : +91 76000 99342  
Email: [hhappydesign@gmail.com](mailto:hhappydesign@gmail.com)  
: [studiothehappydesign@gmail.com](mailto:studiothehappydesign@gmail.com)  
Web: [www.thehappydesign.in](http://www.thehappydesign.in)

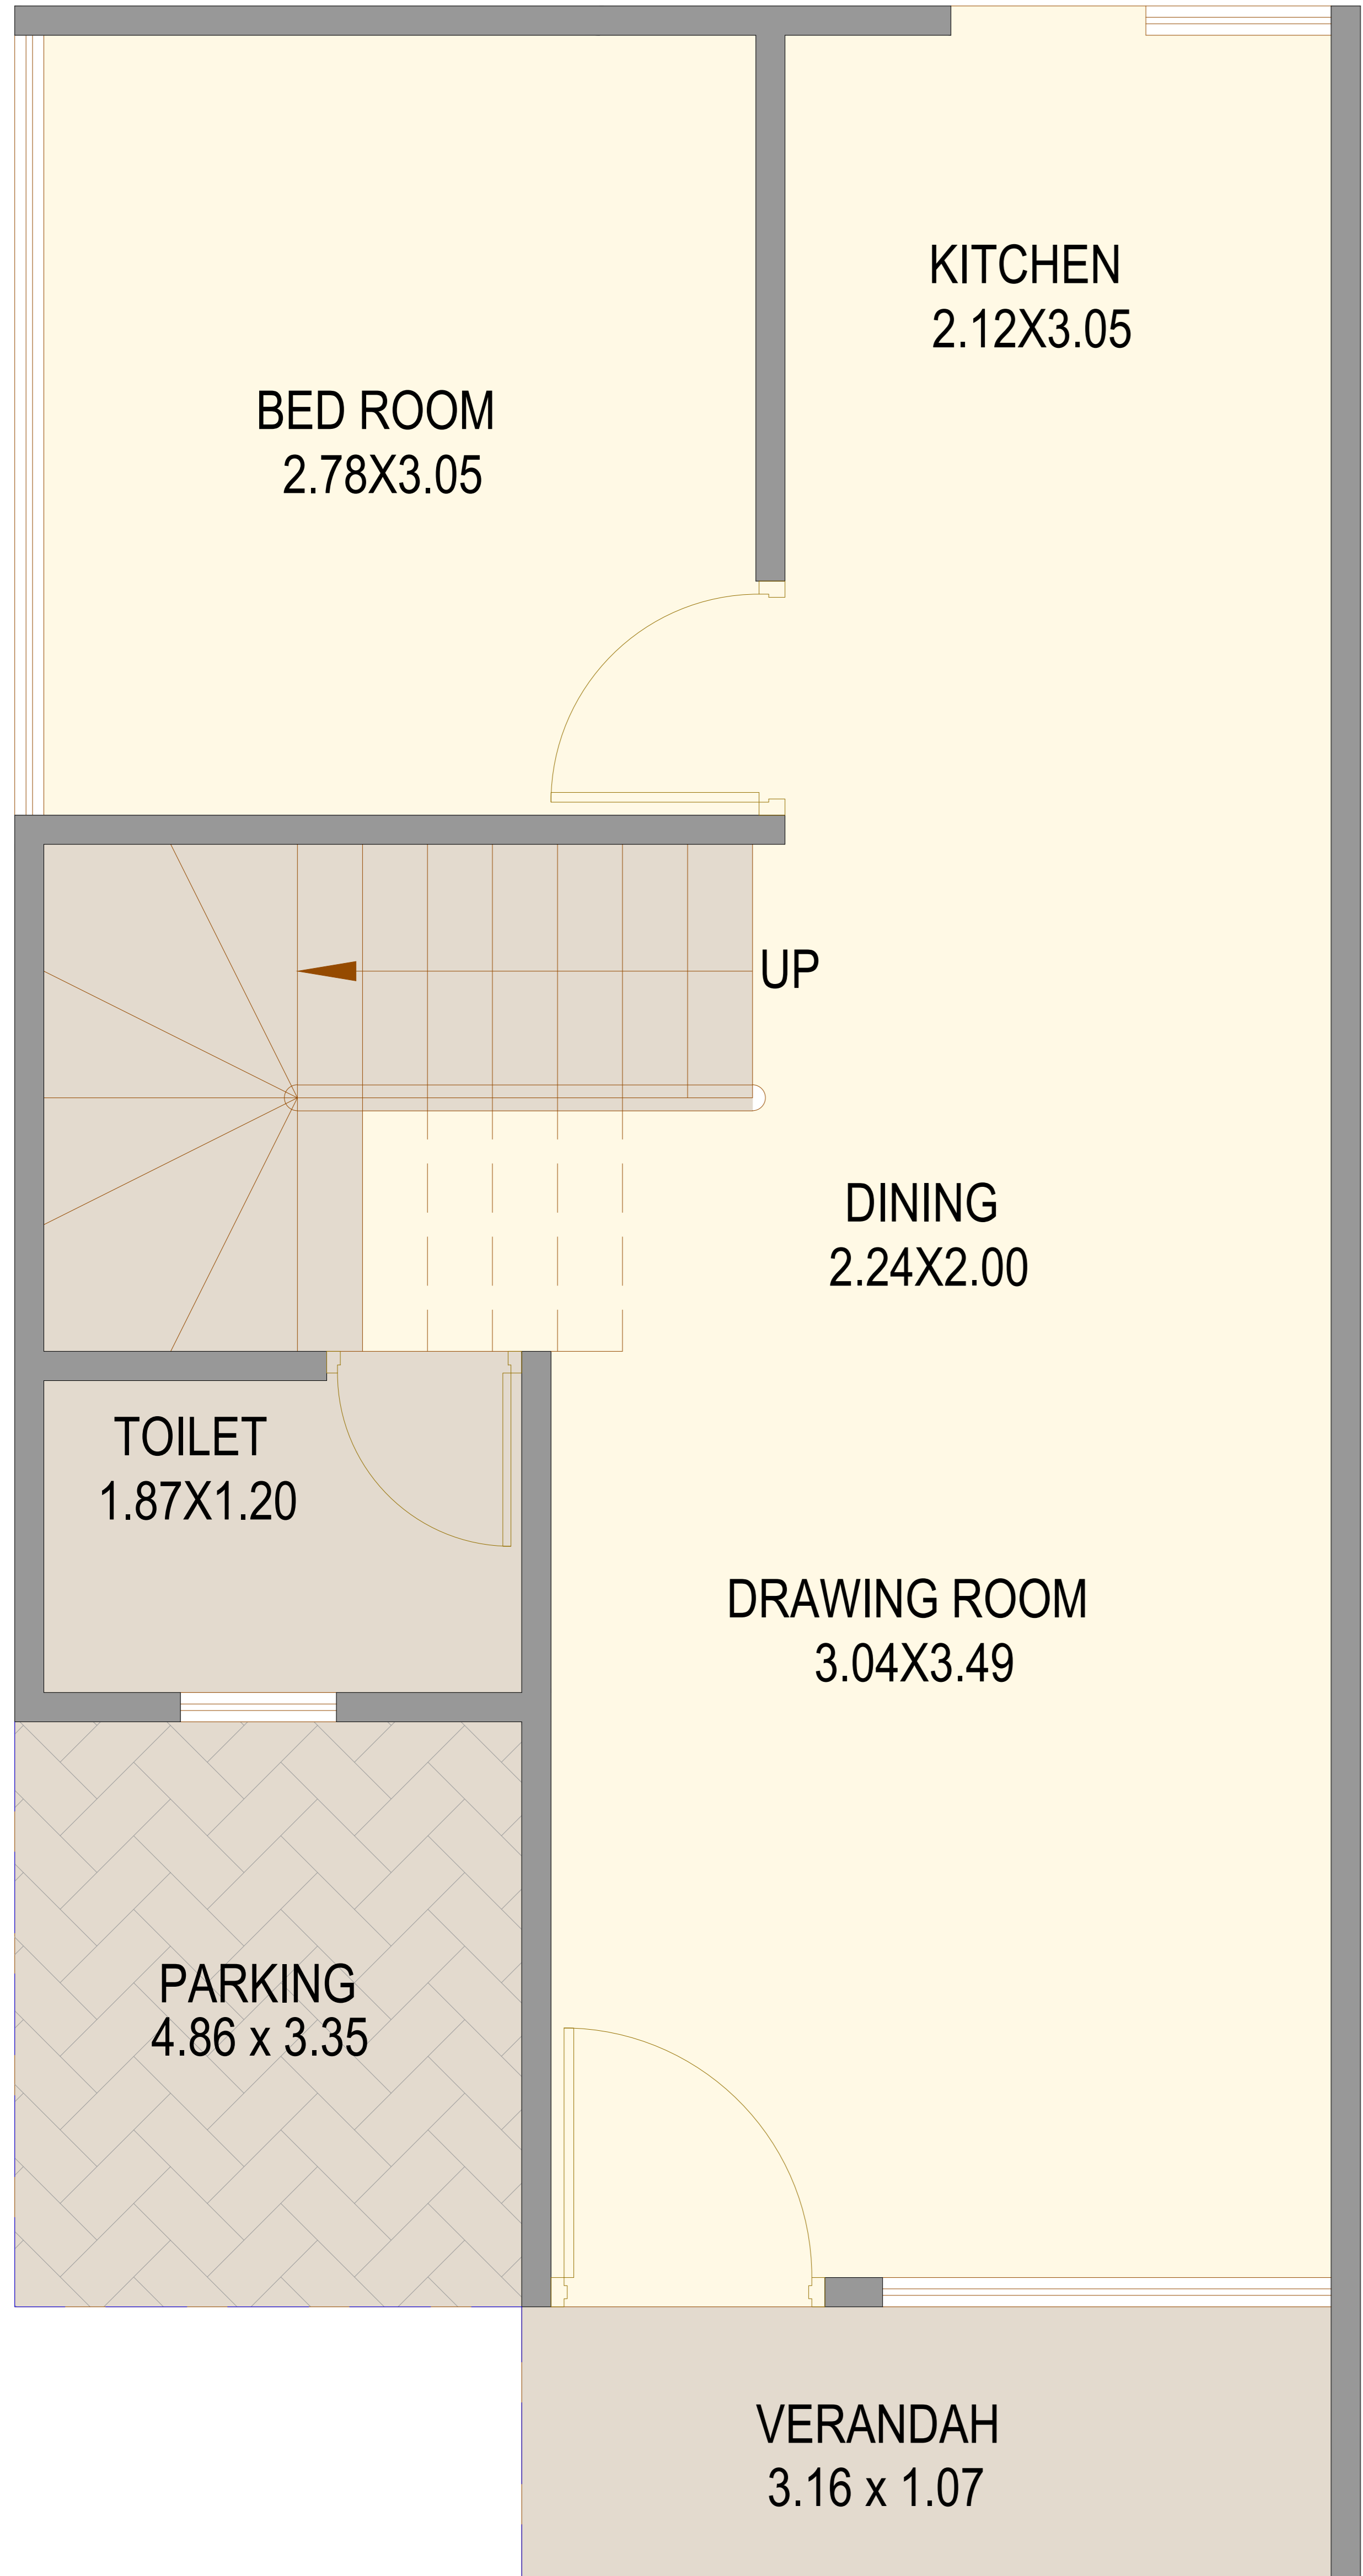




**GROUND FLOOR PLAN**

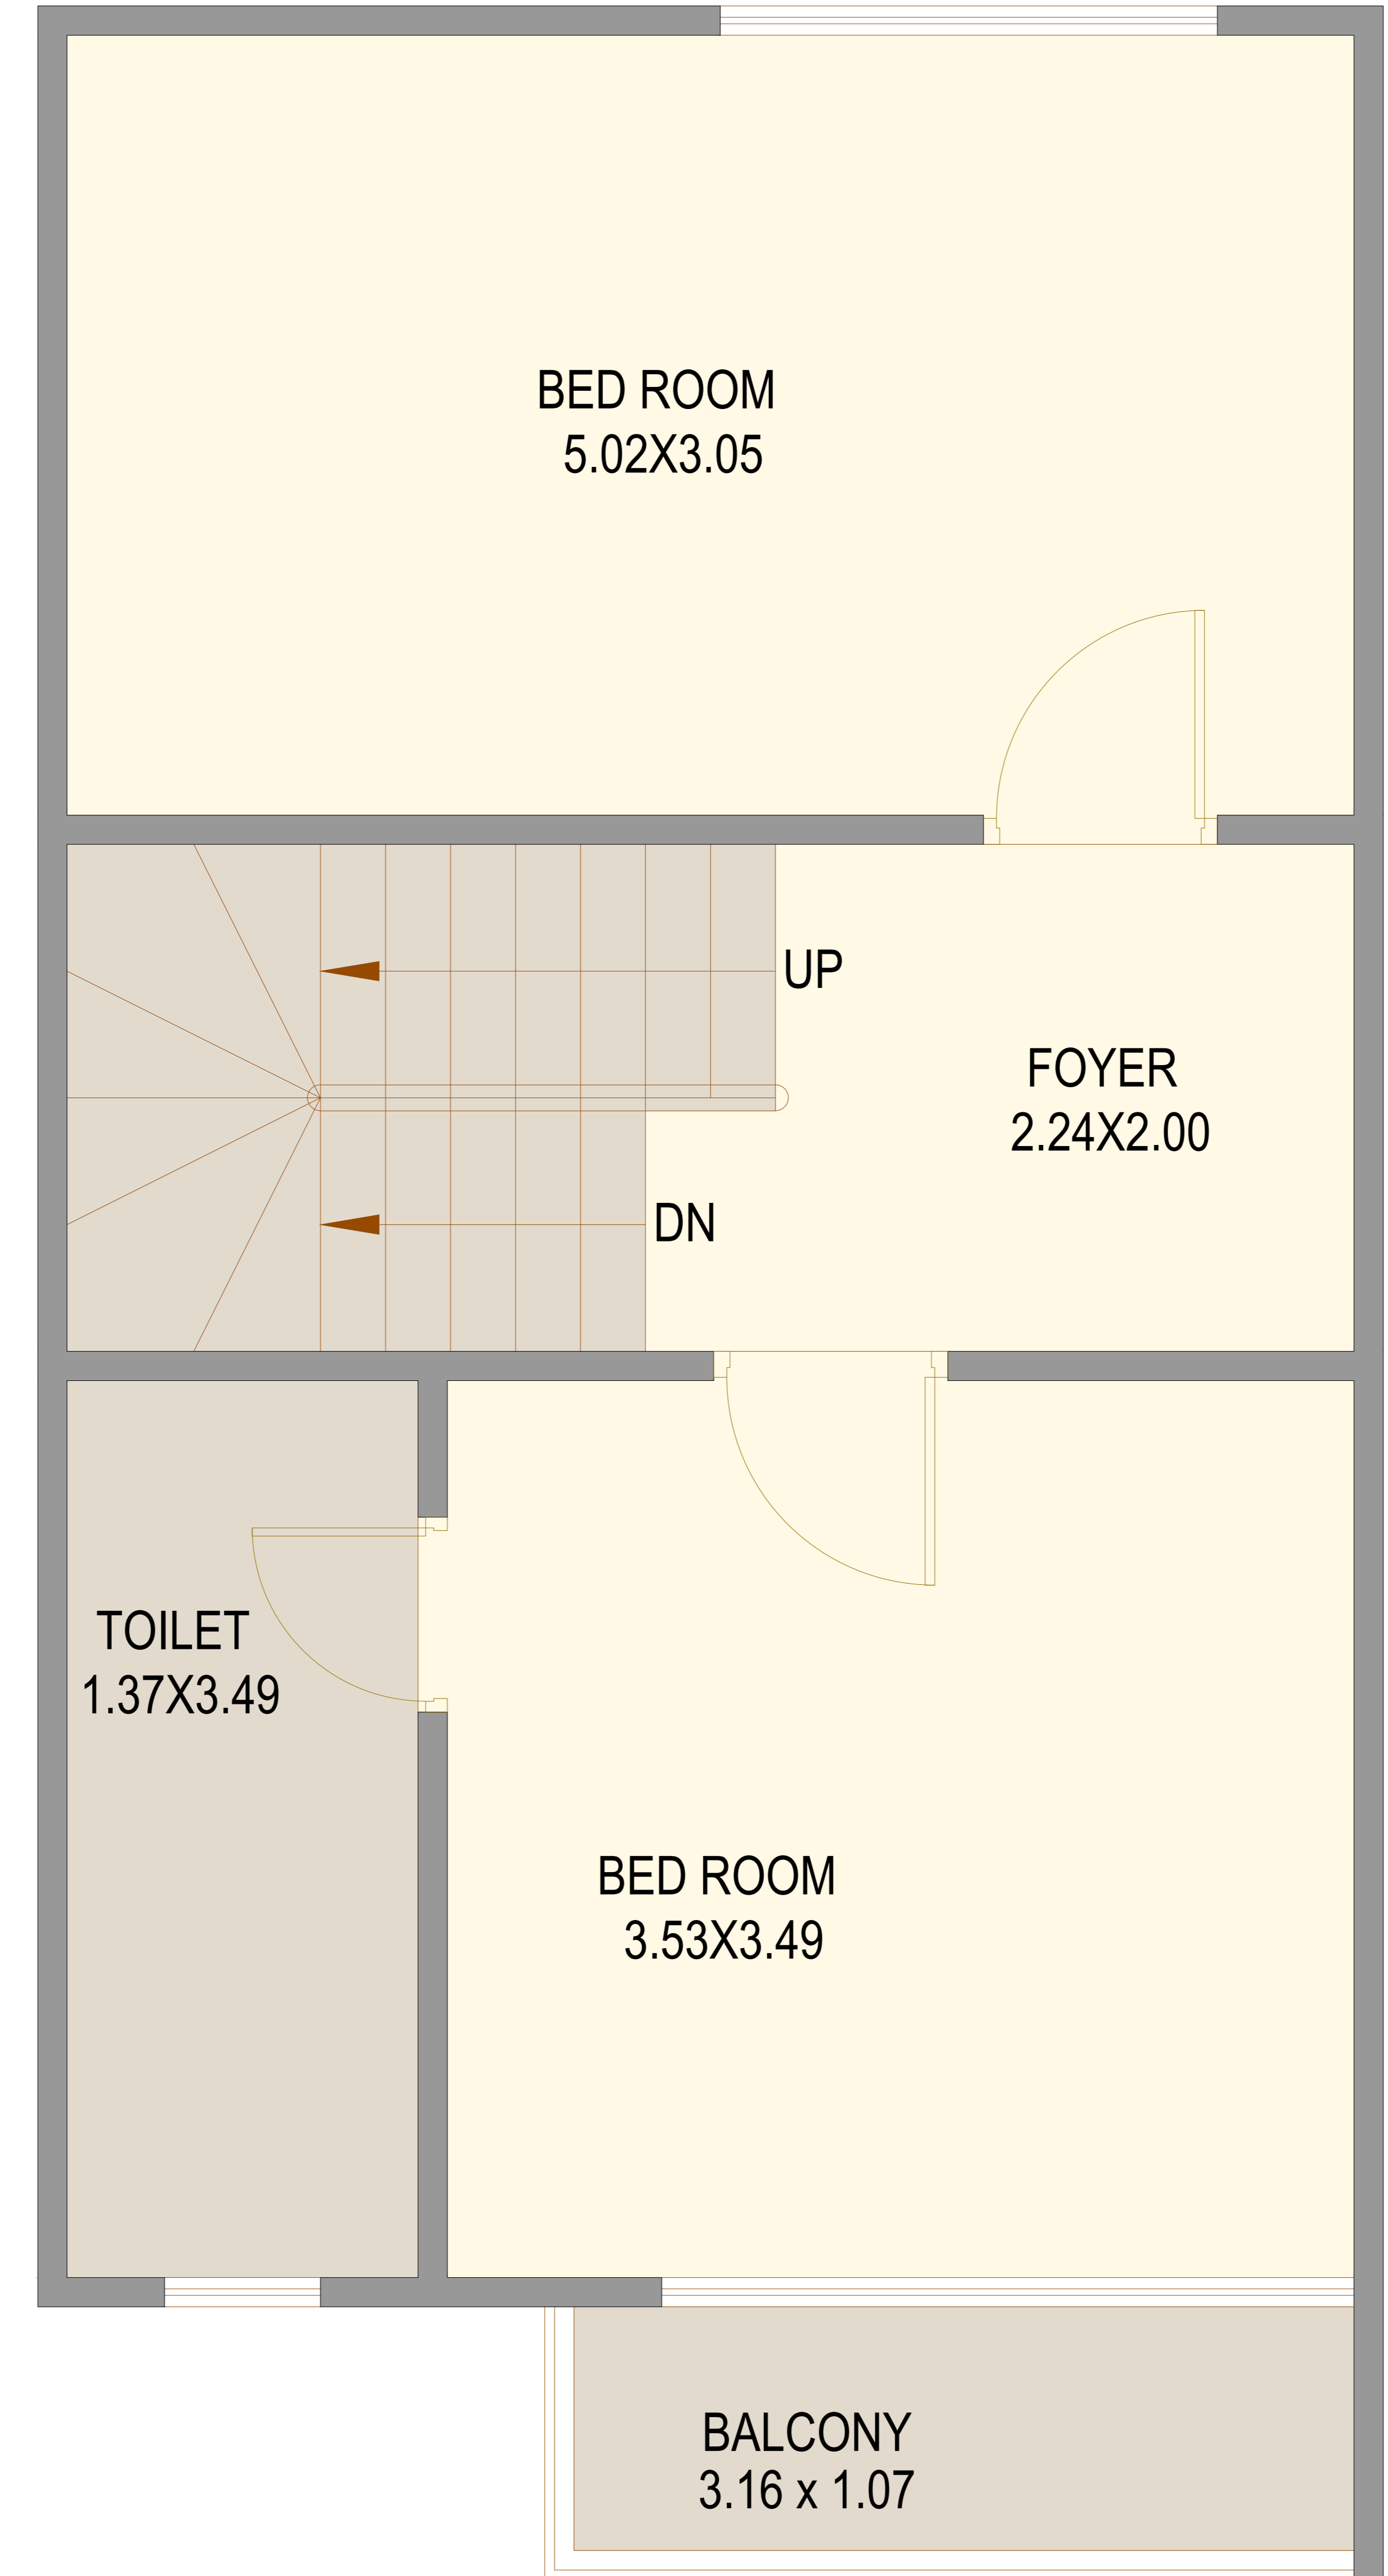

**FIRST FLOOR PLAN**

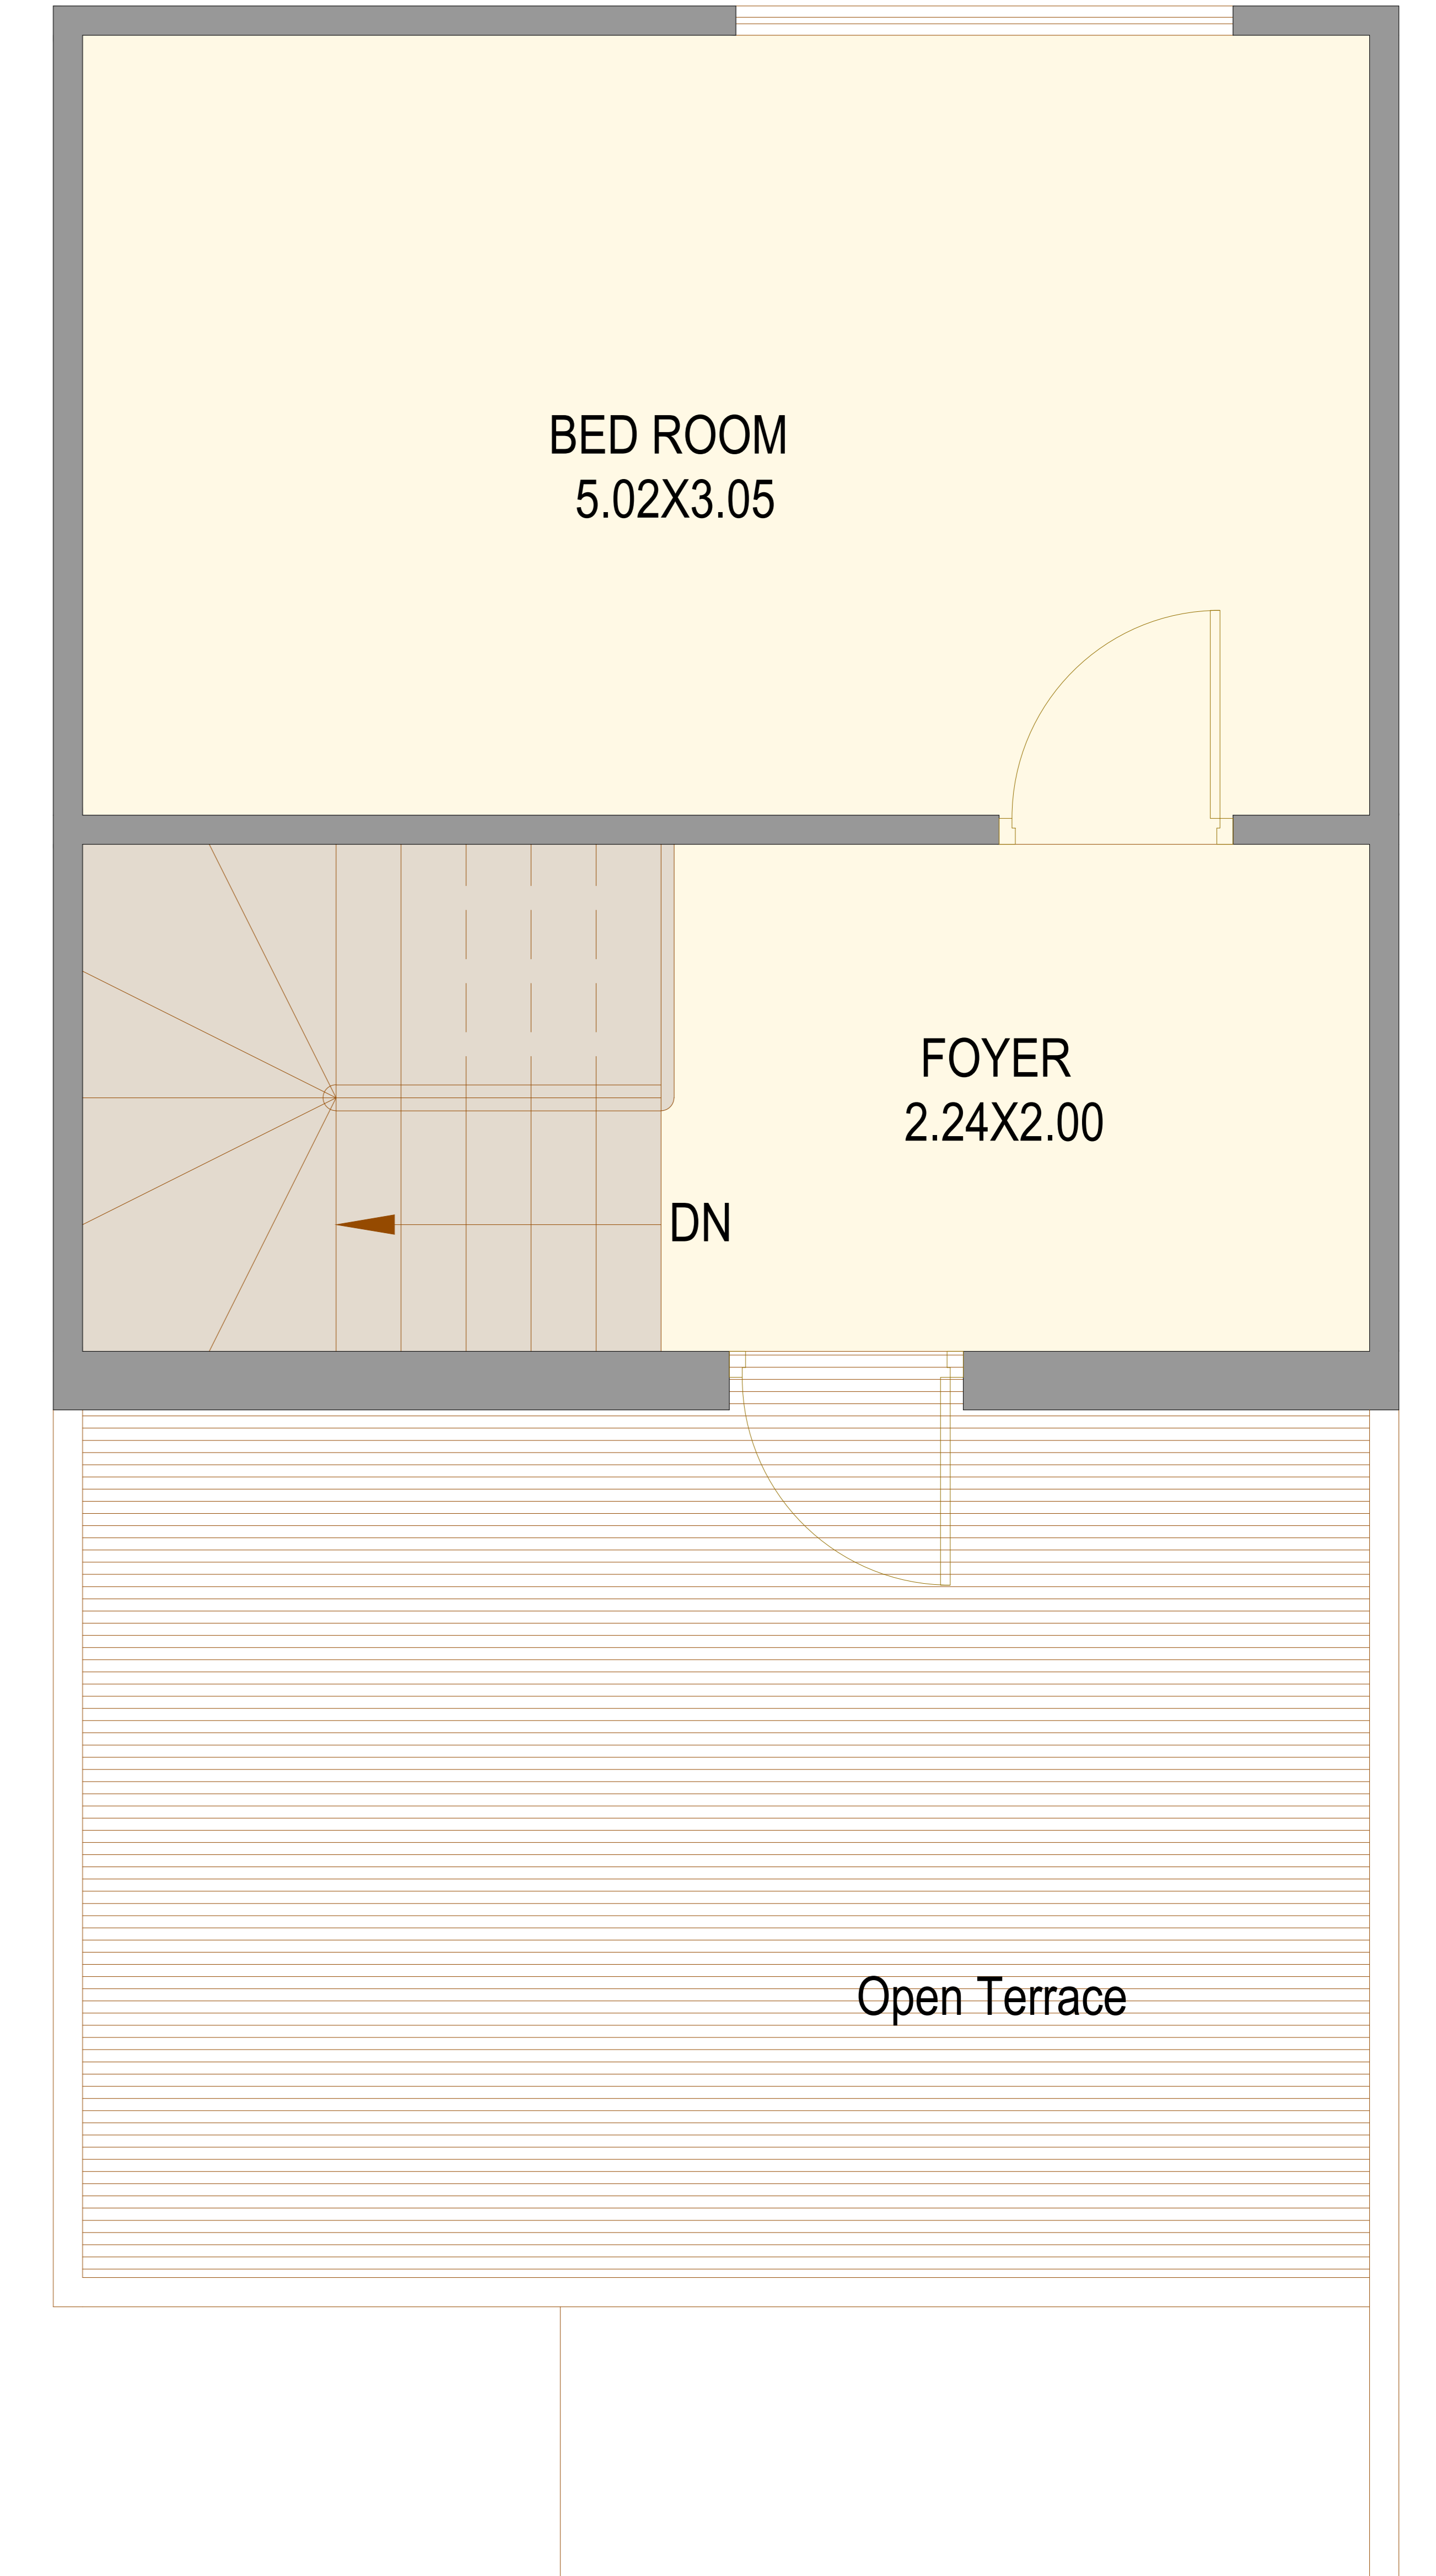

**SECOND FLOOR PLAN**

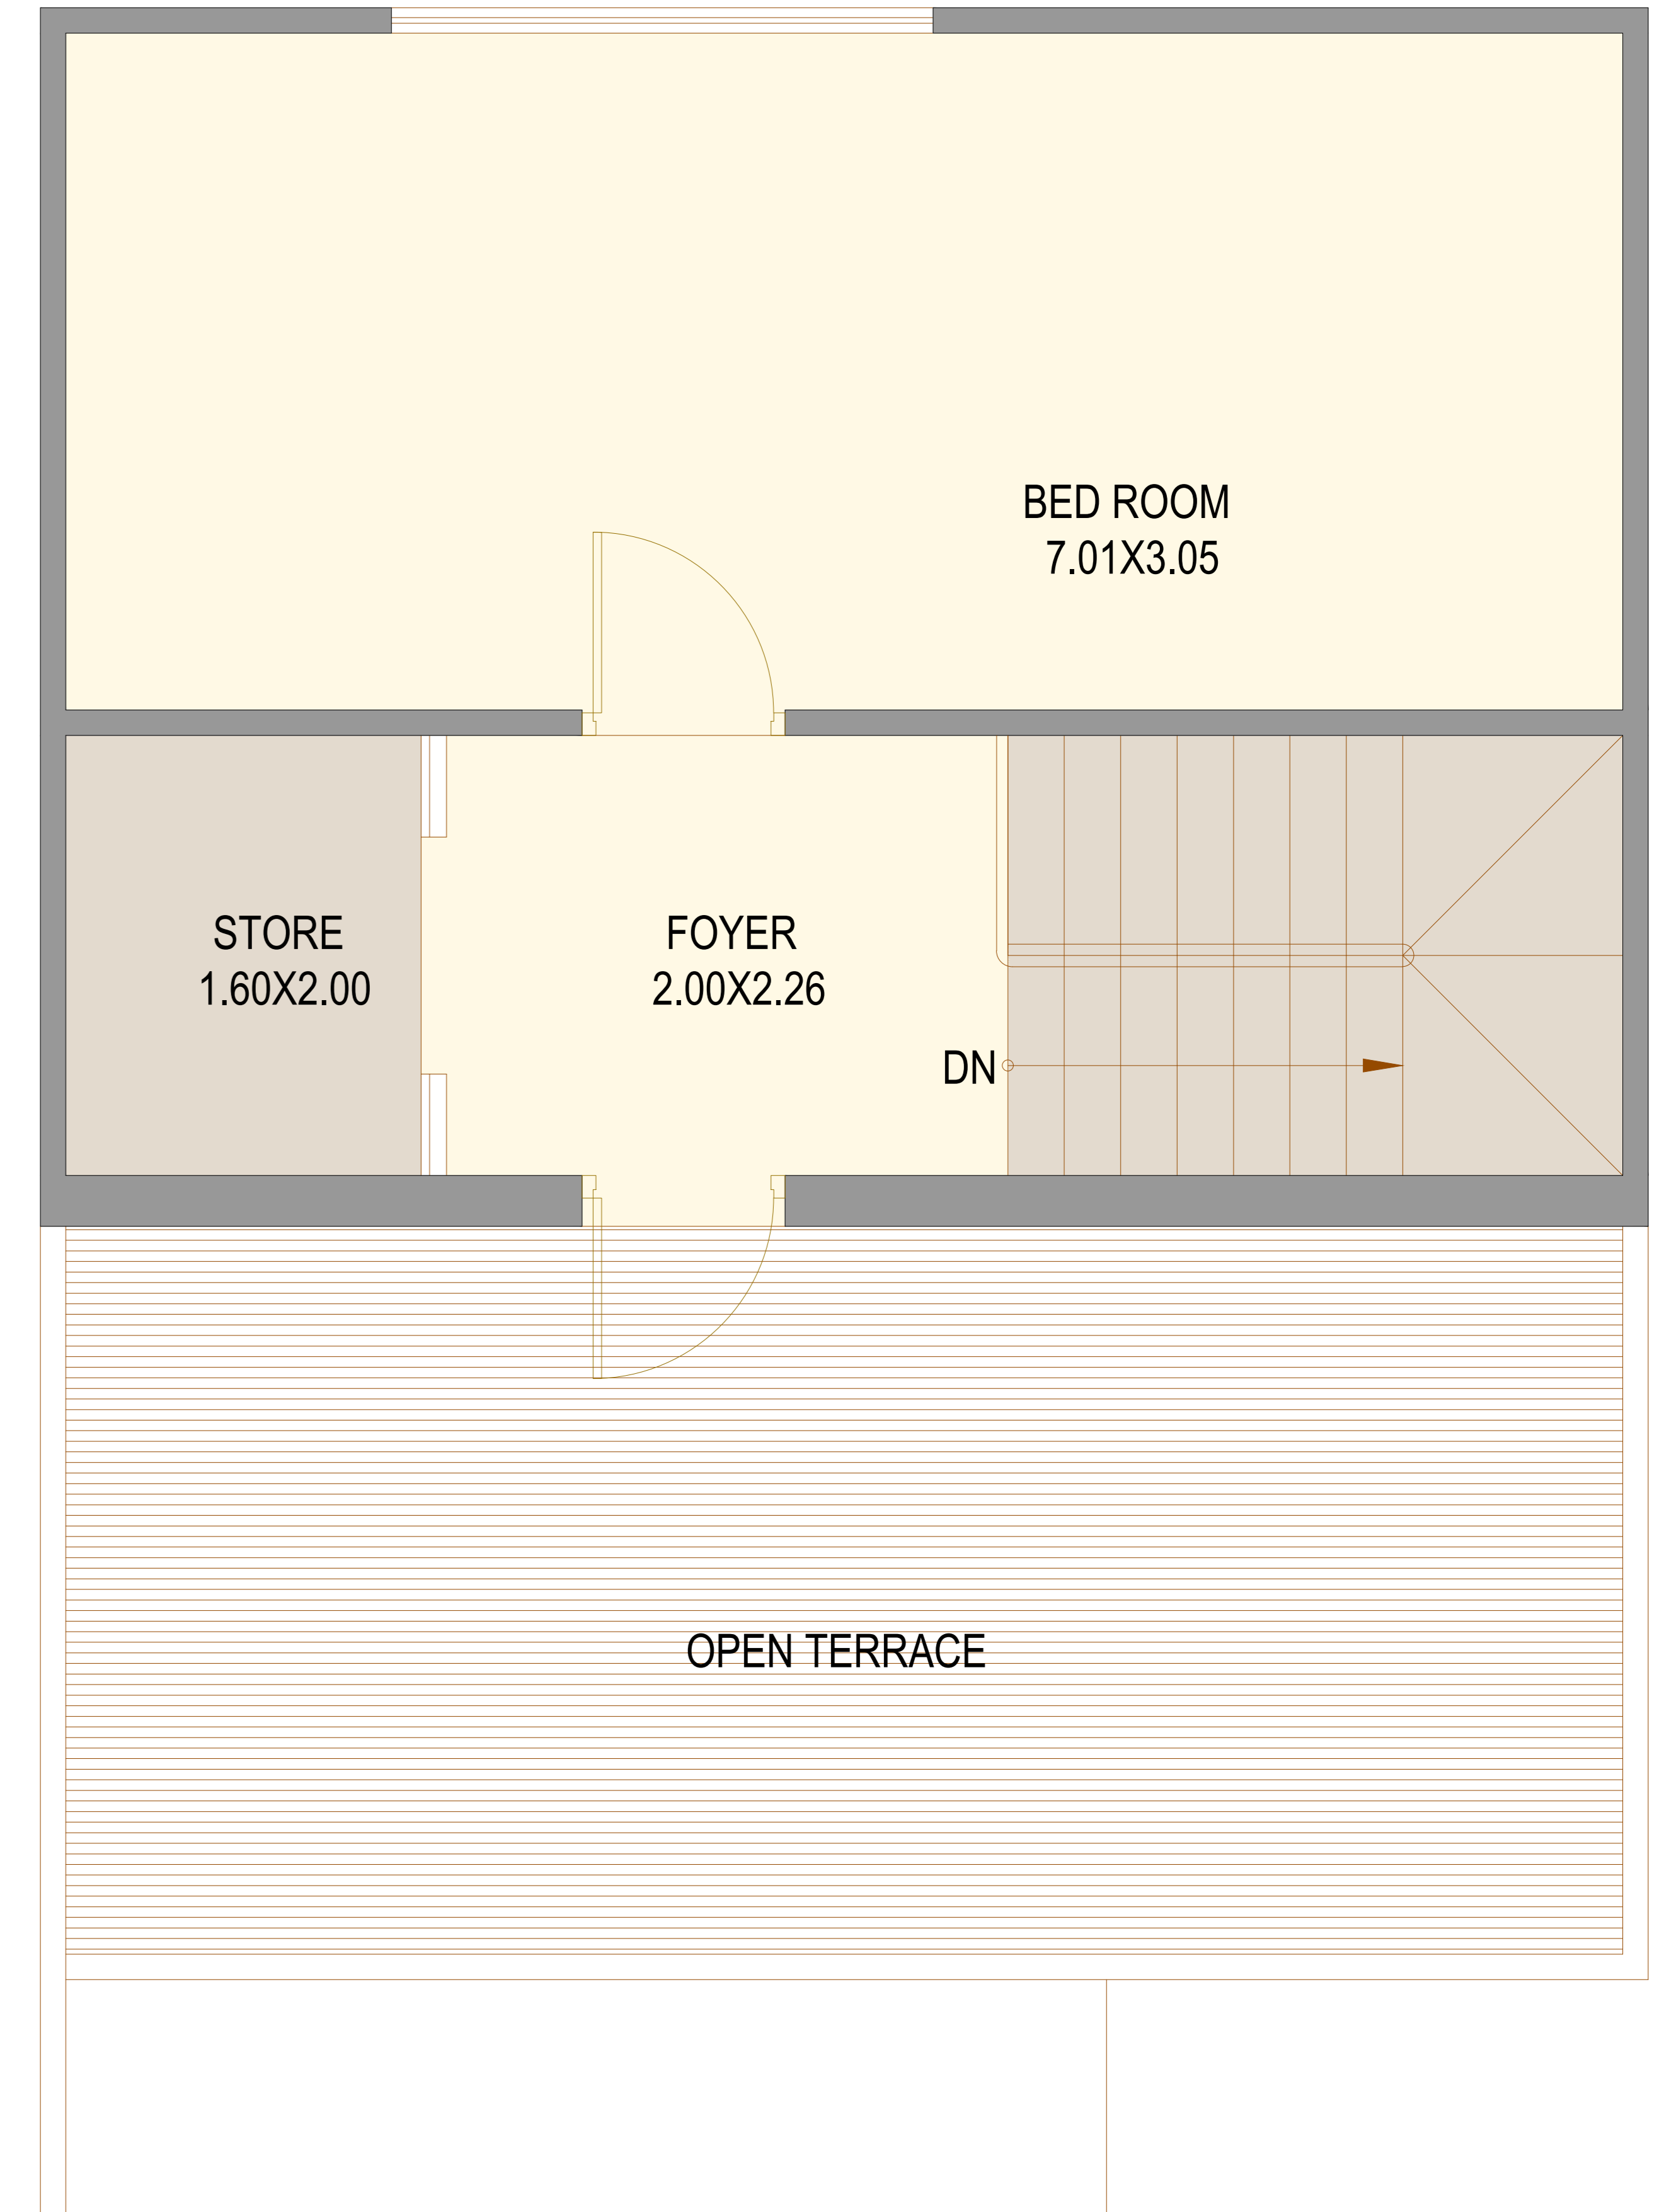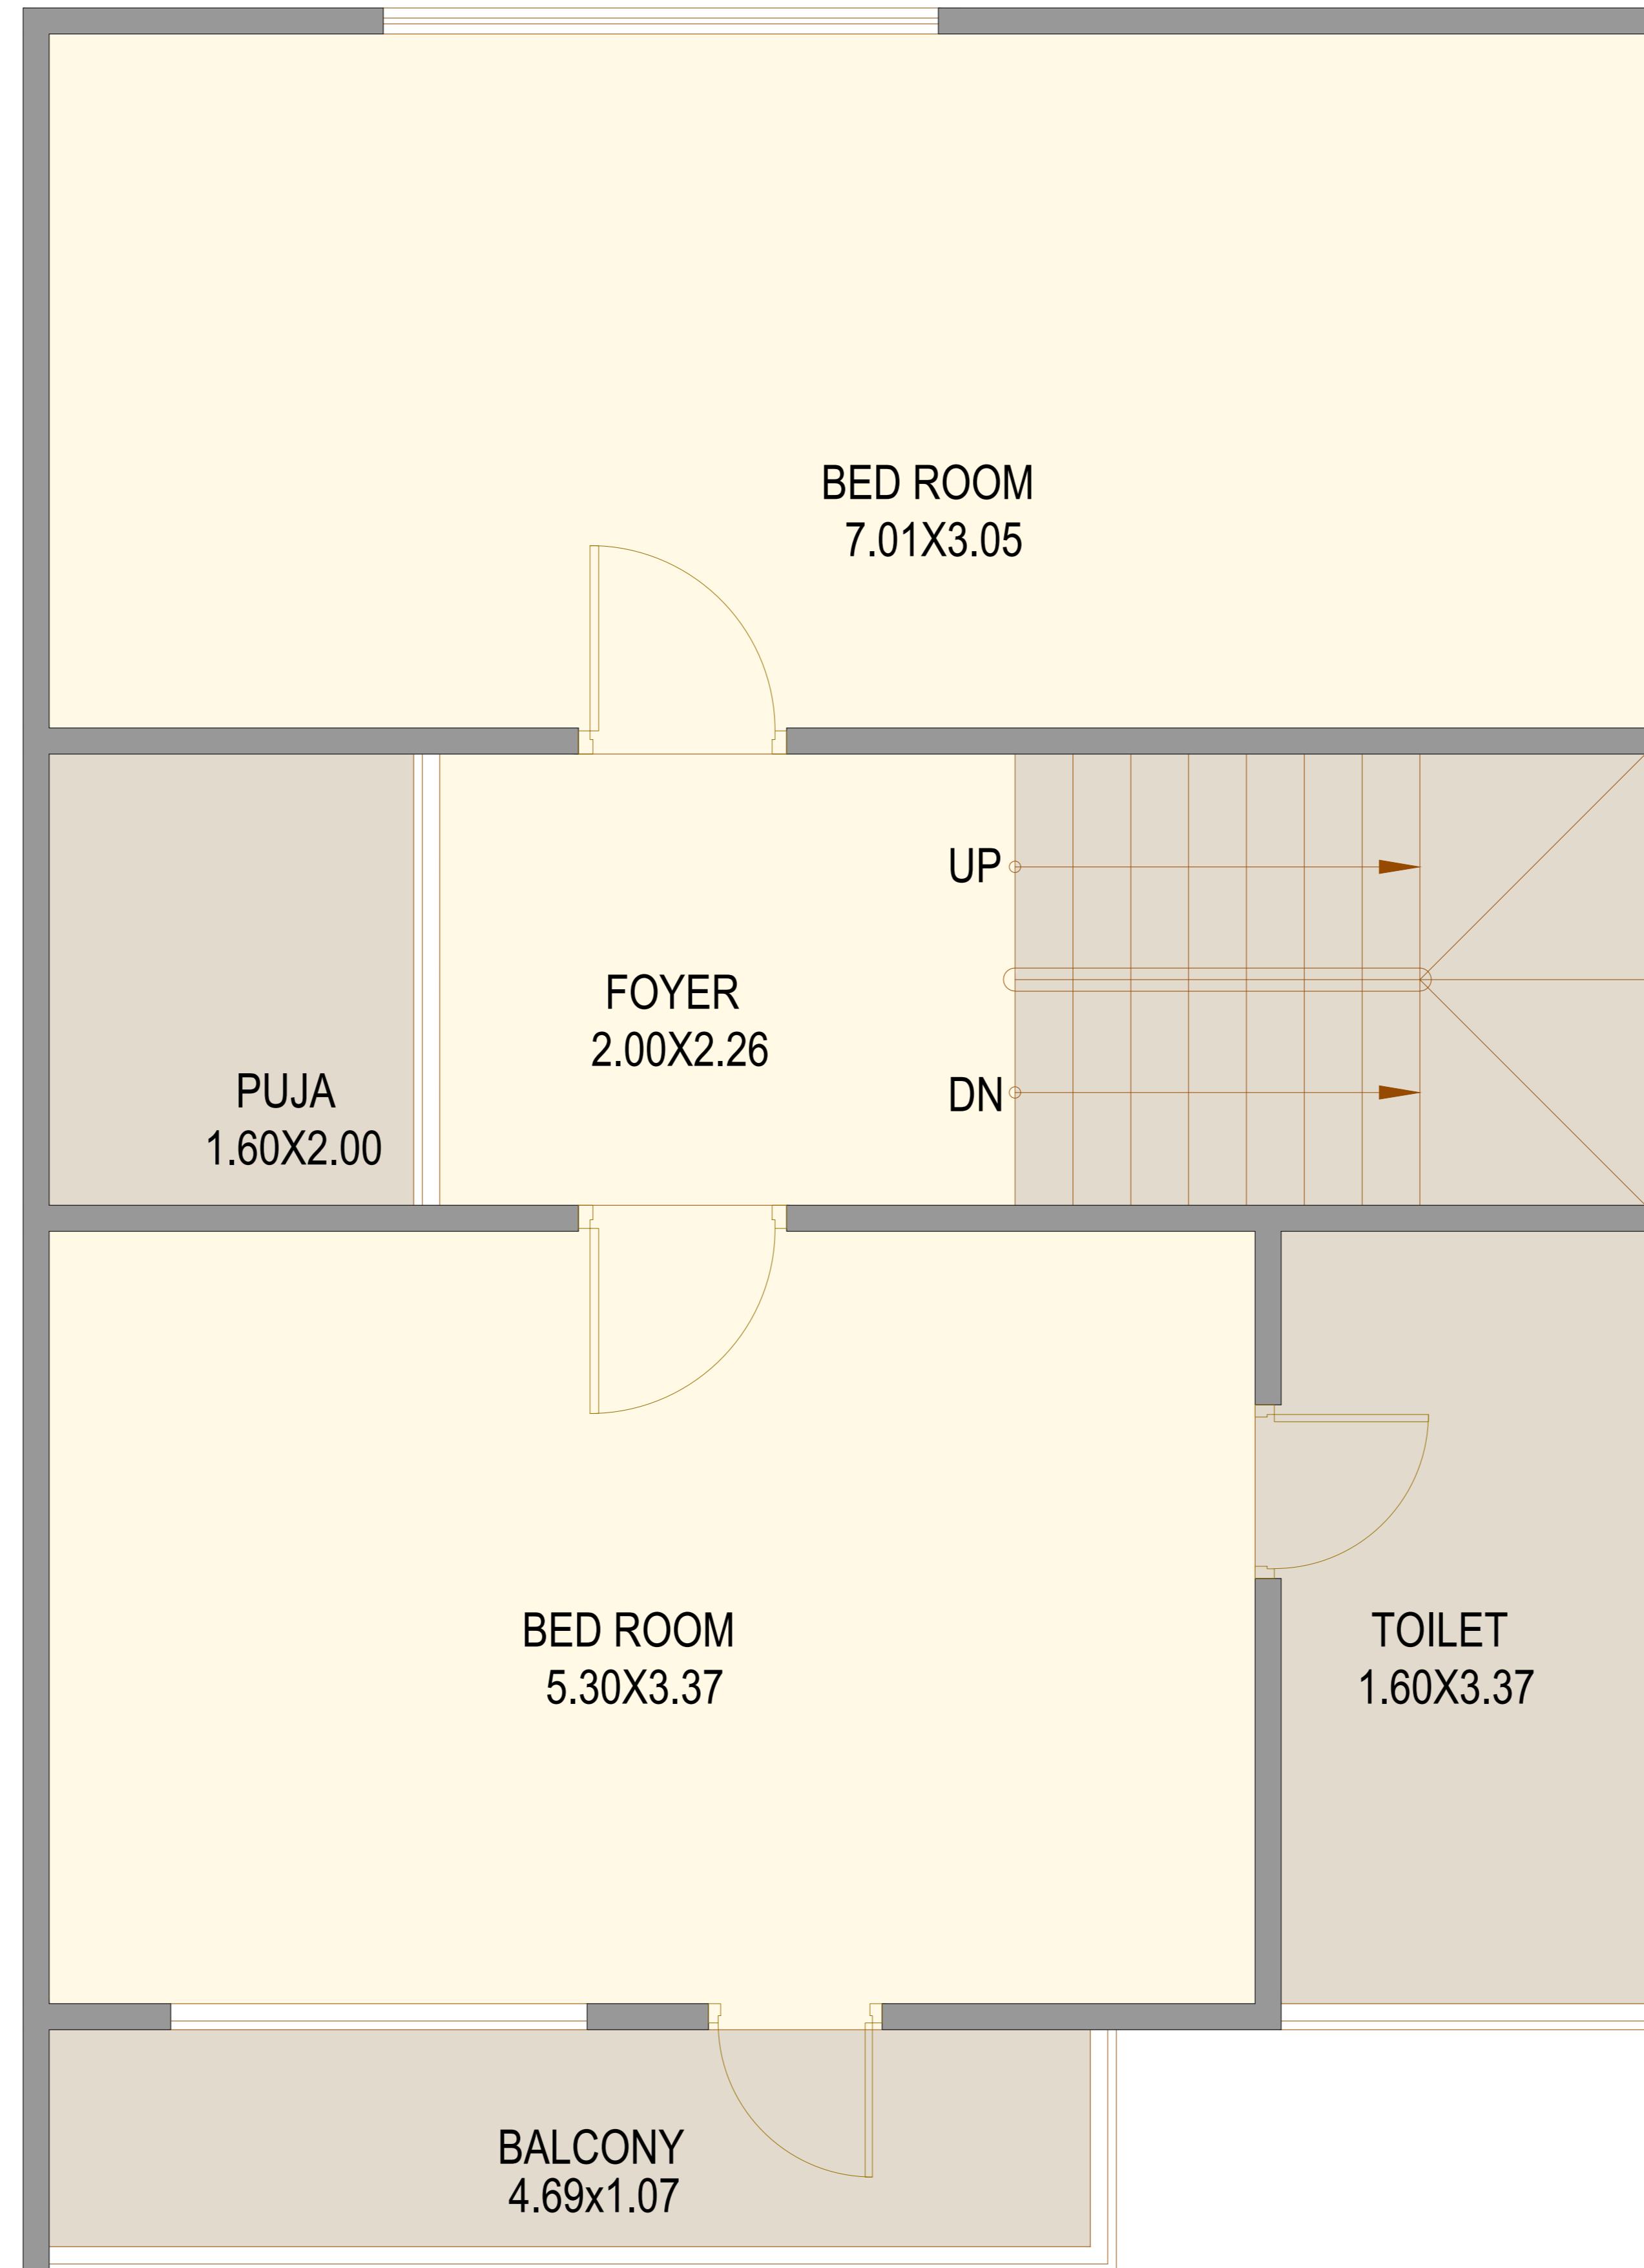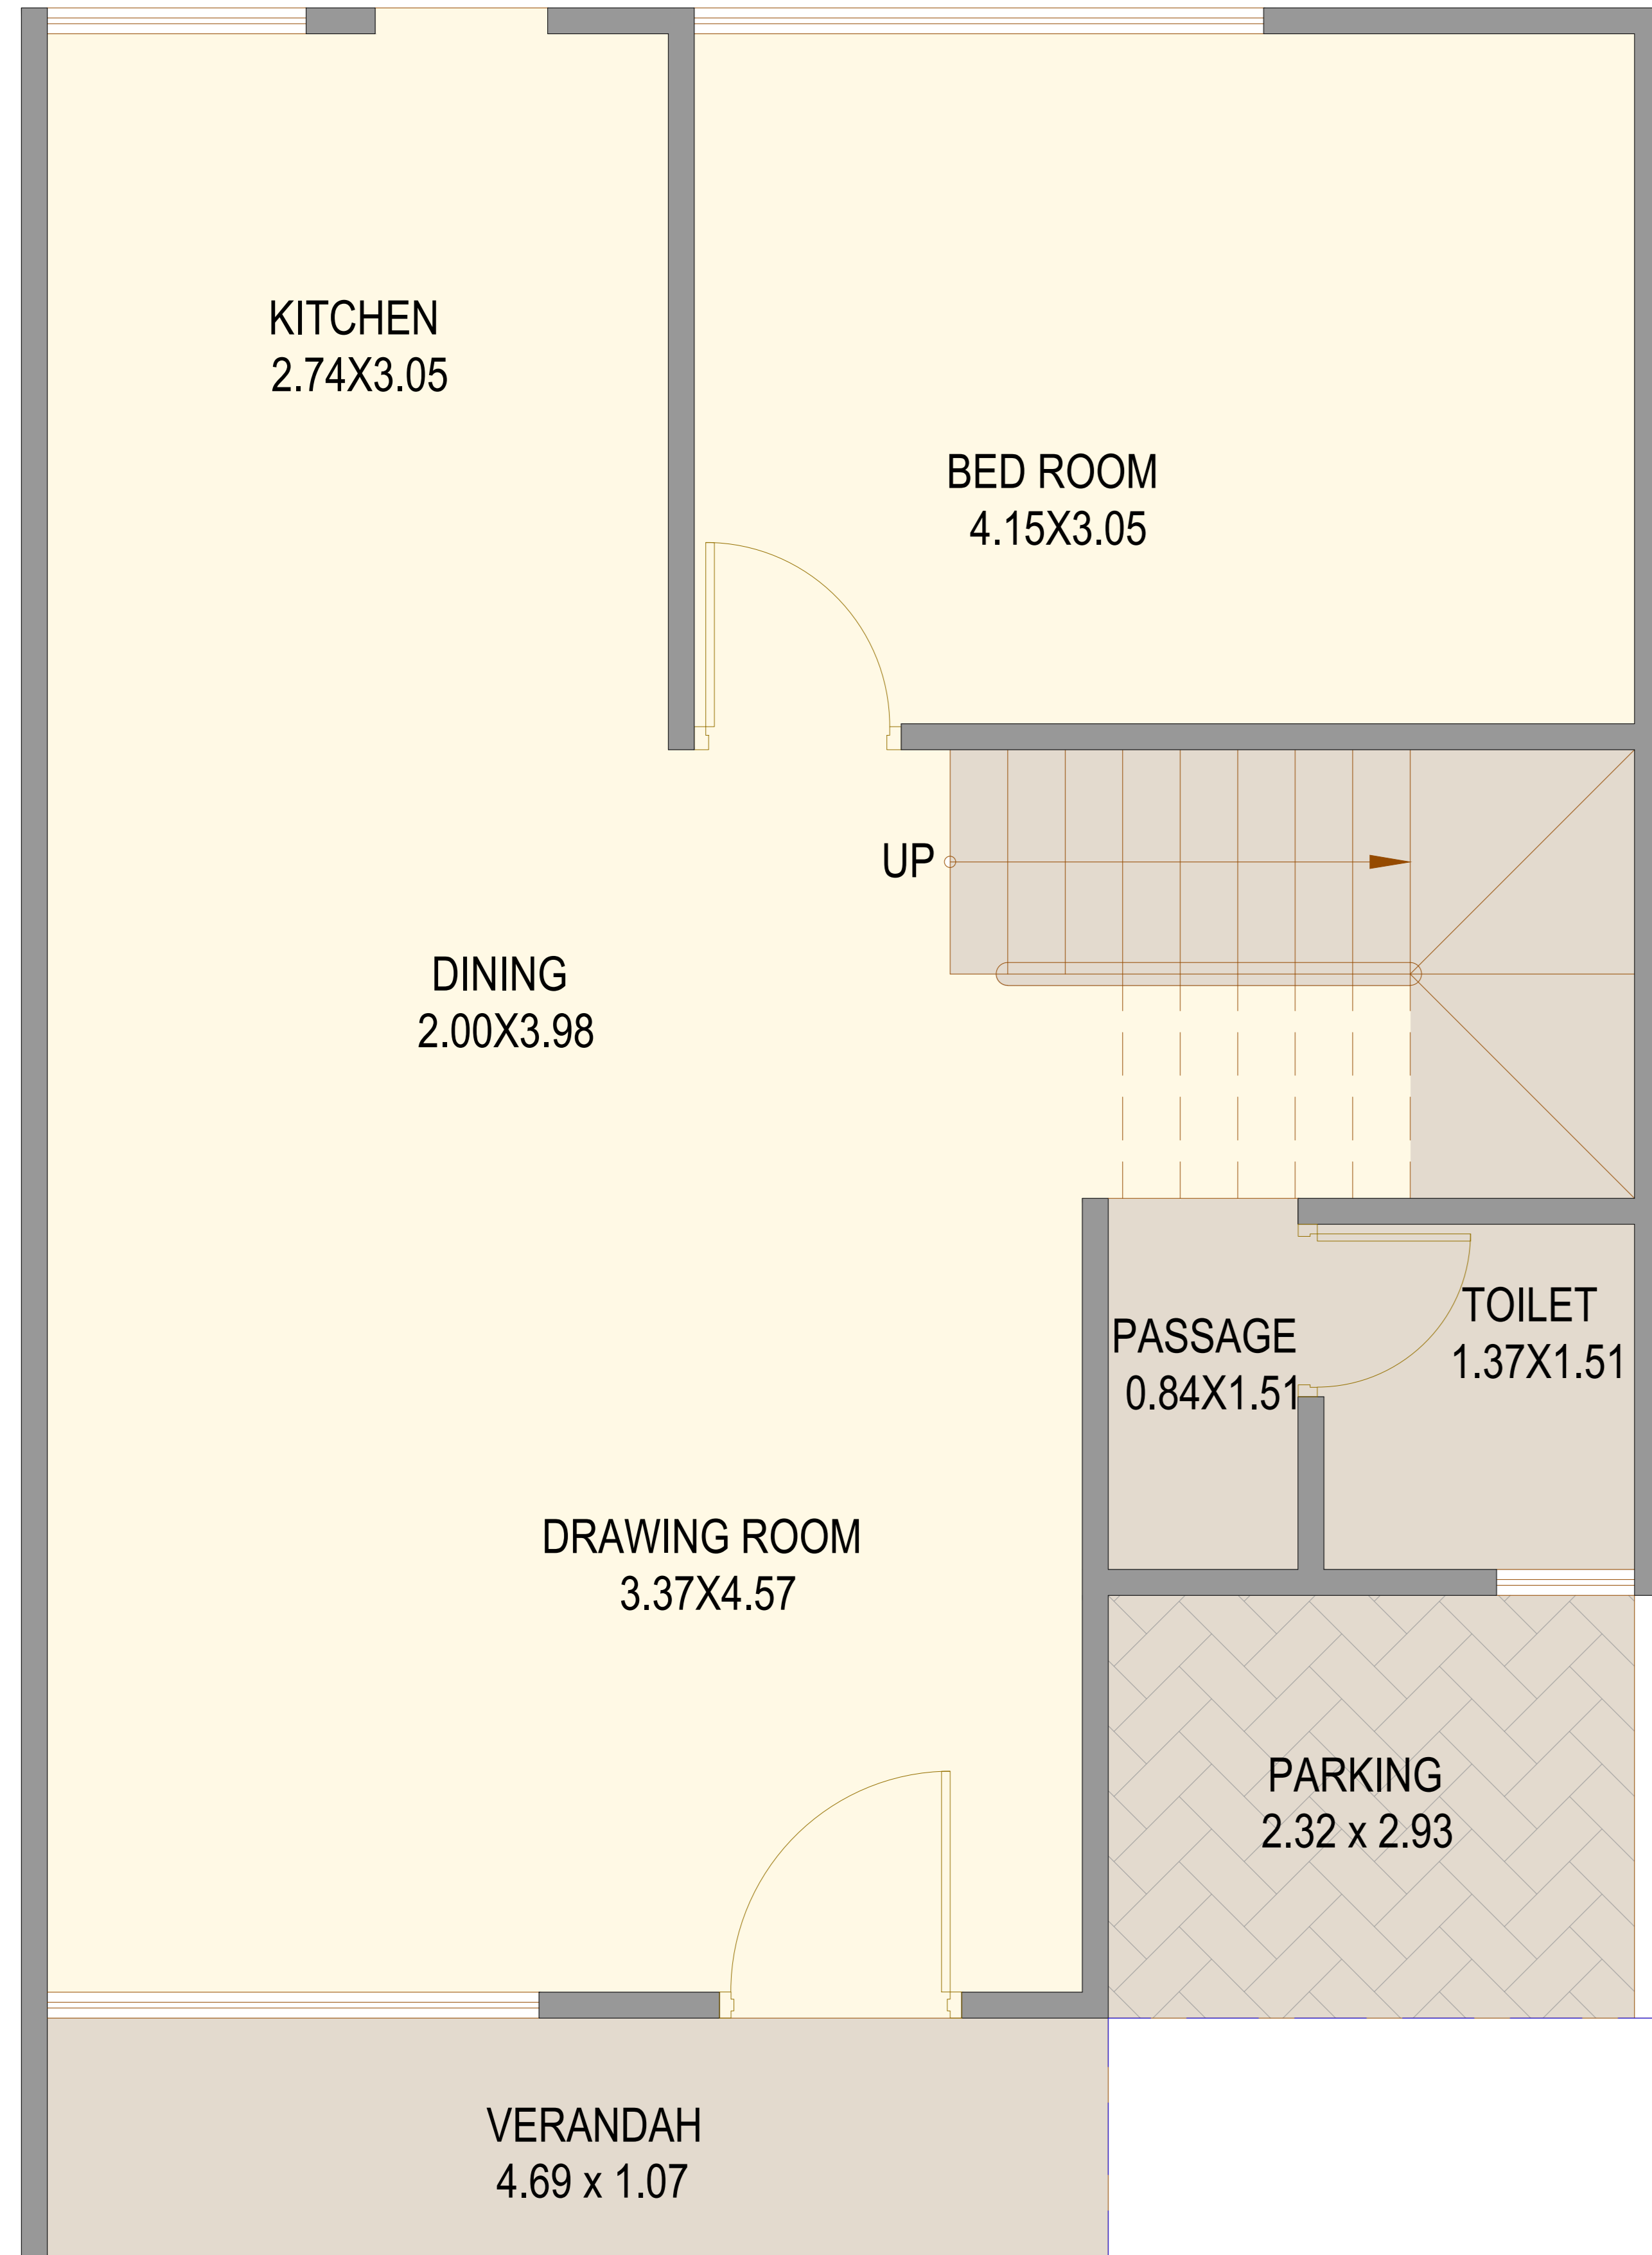

**GROUND FLOOR PLAN**

**FIRST FLOOR PLAN**

**SECOND FLOOR PLAN**

PROJECT NAME : RAINBOW VILLA'S


DRG. TITLE : FLOOR PLAN

(E-1, F-2, G-1, F-1, H-1)  
(UNIT -13 TO 17)

LOCATED

@  
LAMBHA

NORTH LOCATION

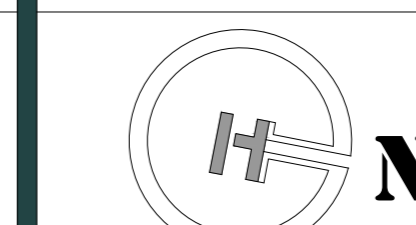

DRG. SCALE

NOT TO SCALE


DATE : 20.01.2023

DRN. BY : PARESH


CHK. BY : VIRAL PATEL

The HAPPY DESIGN


FF-9, SHRINIVAS COMPLEX,  
OPP. VAIBHAV HALL, GHODASAR,  
AHMEDABAD. 380050  
M : +91 98984 34241  
M : +91 76000 99342  
Email: [thappydesign@gmail.com](mailto:thappydesign@gmail.com)  
[studiothehappydesign@gmail.com](mailto:studiothehappydesign@gmail.com)  
Web: [www.thehappydesign.in](http://www.thehappydesign.in)

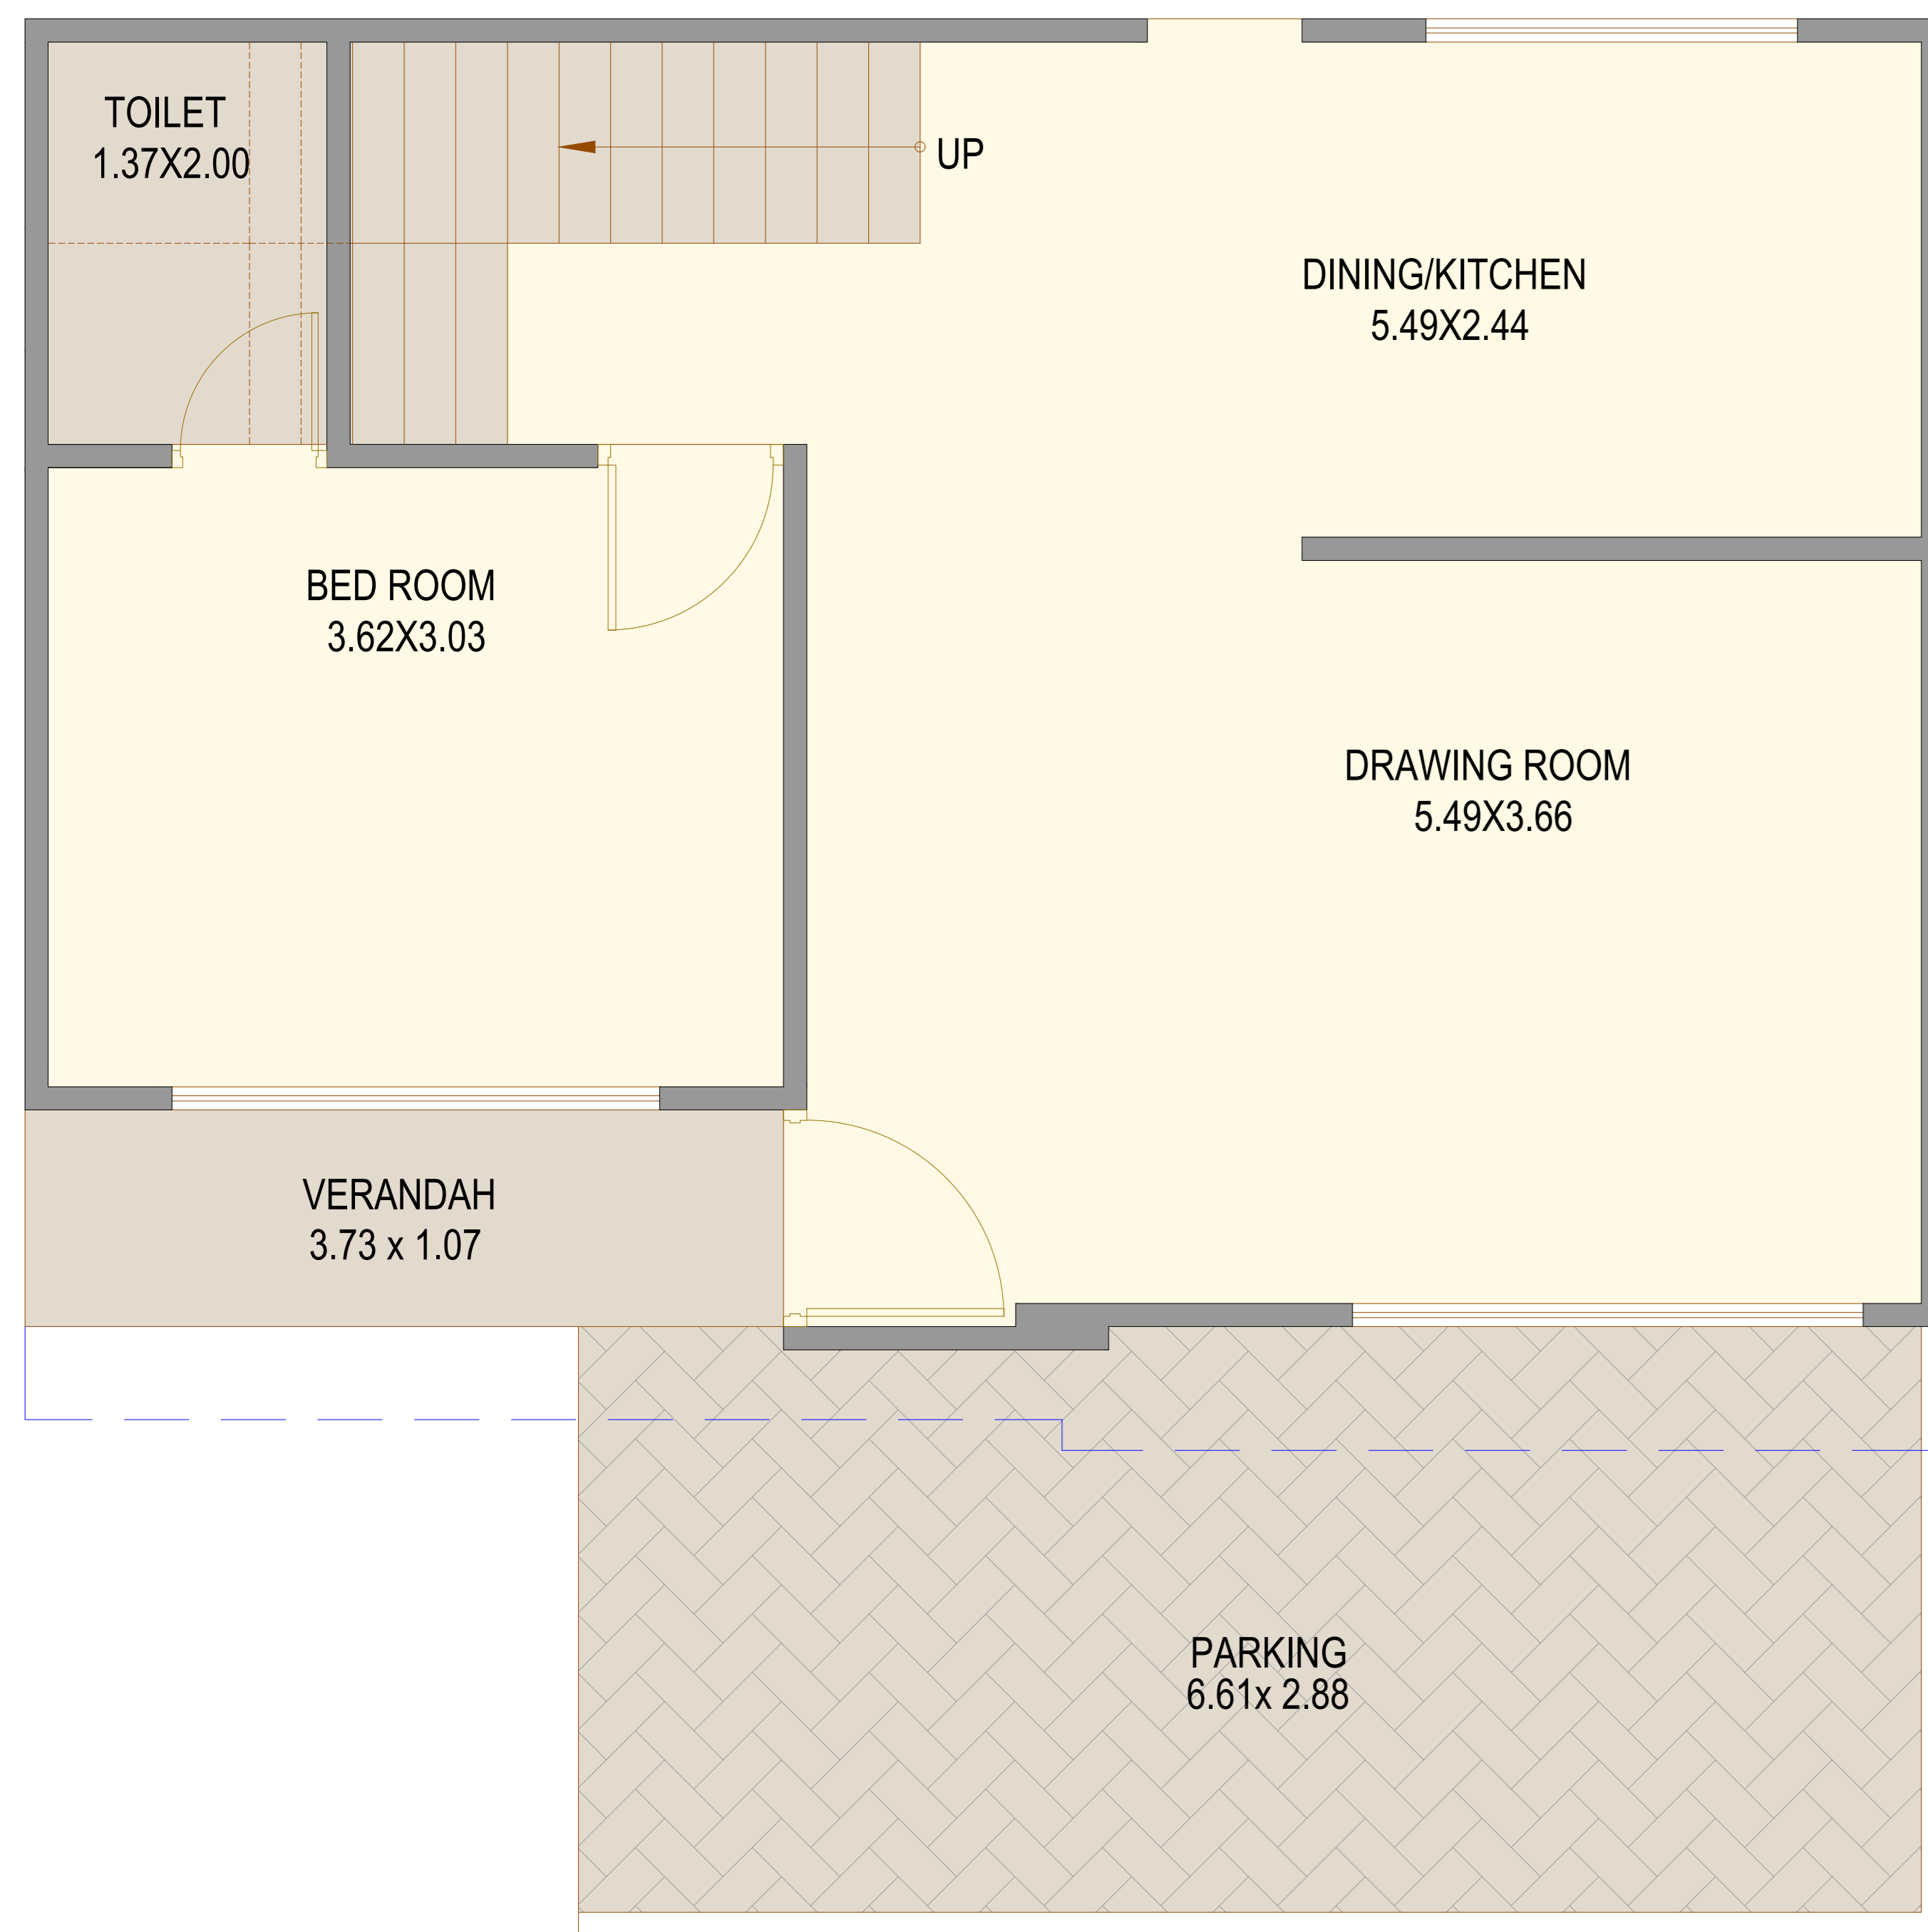

**GROUND FLOOR PLAN**

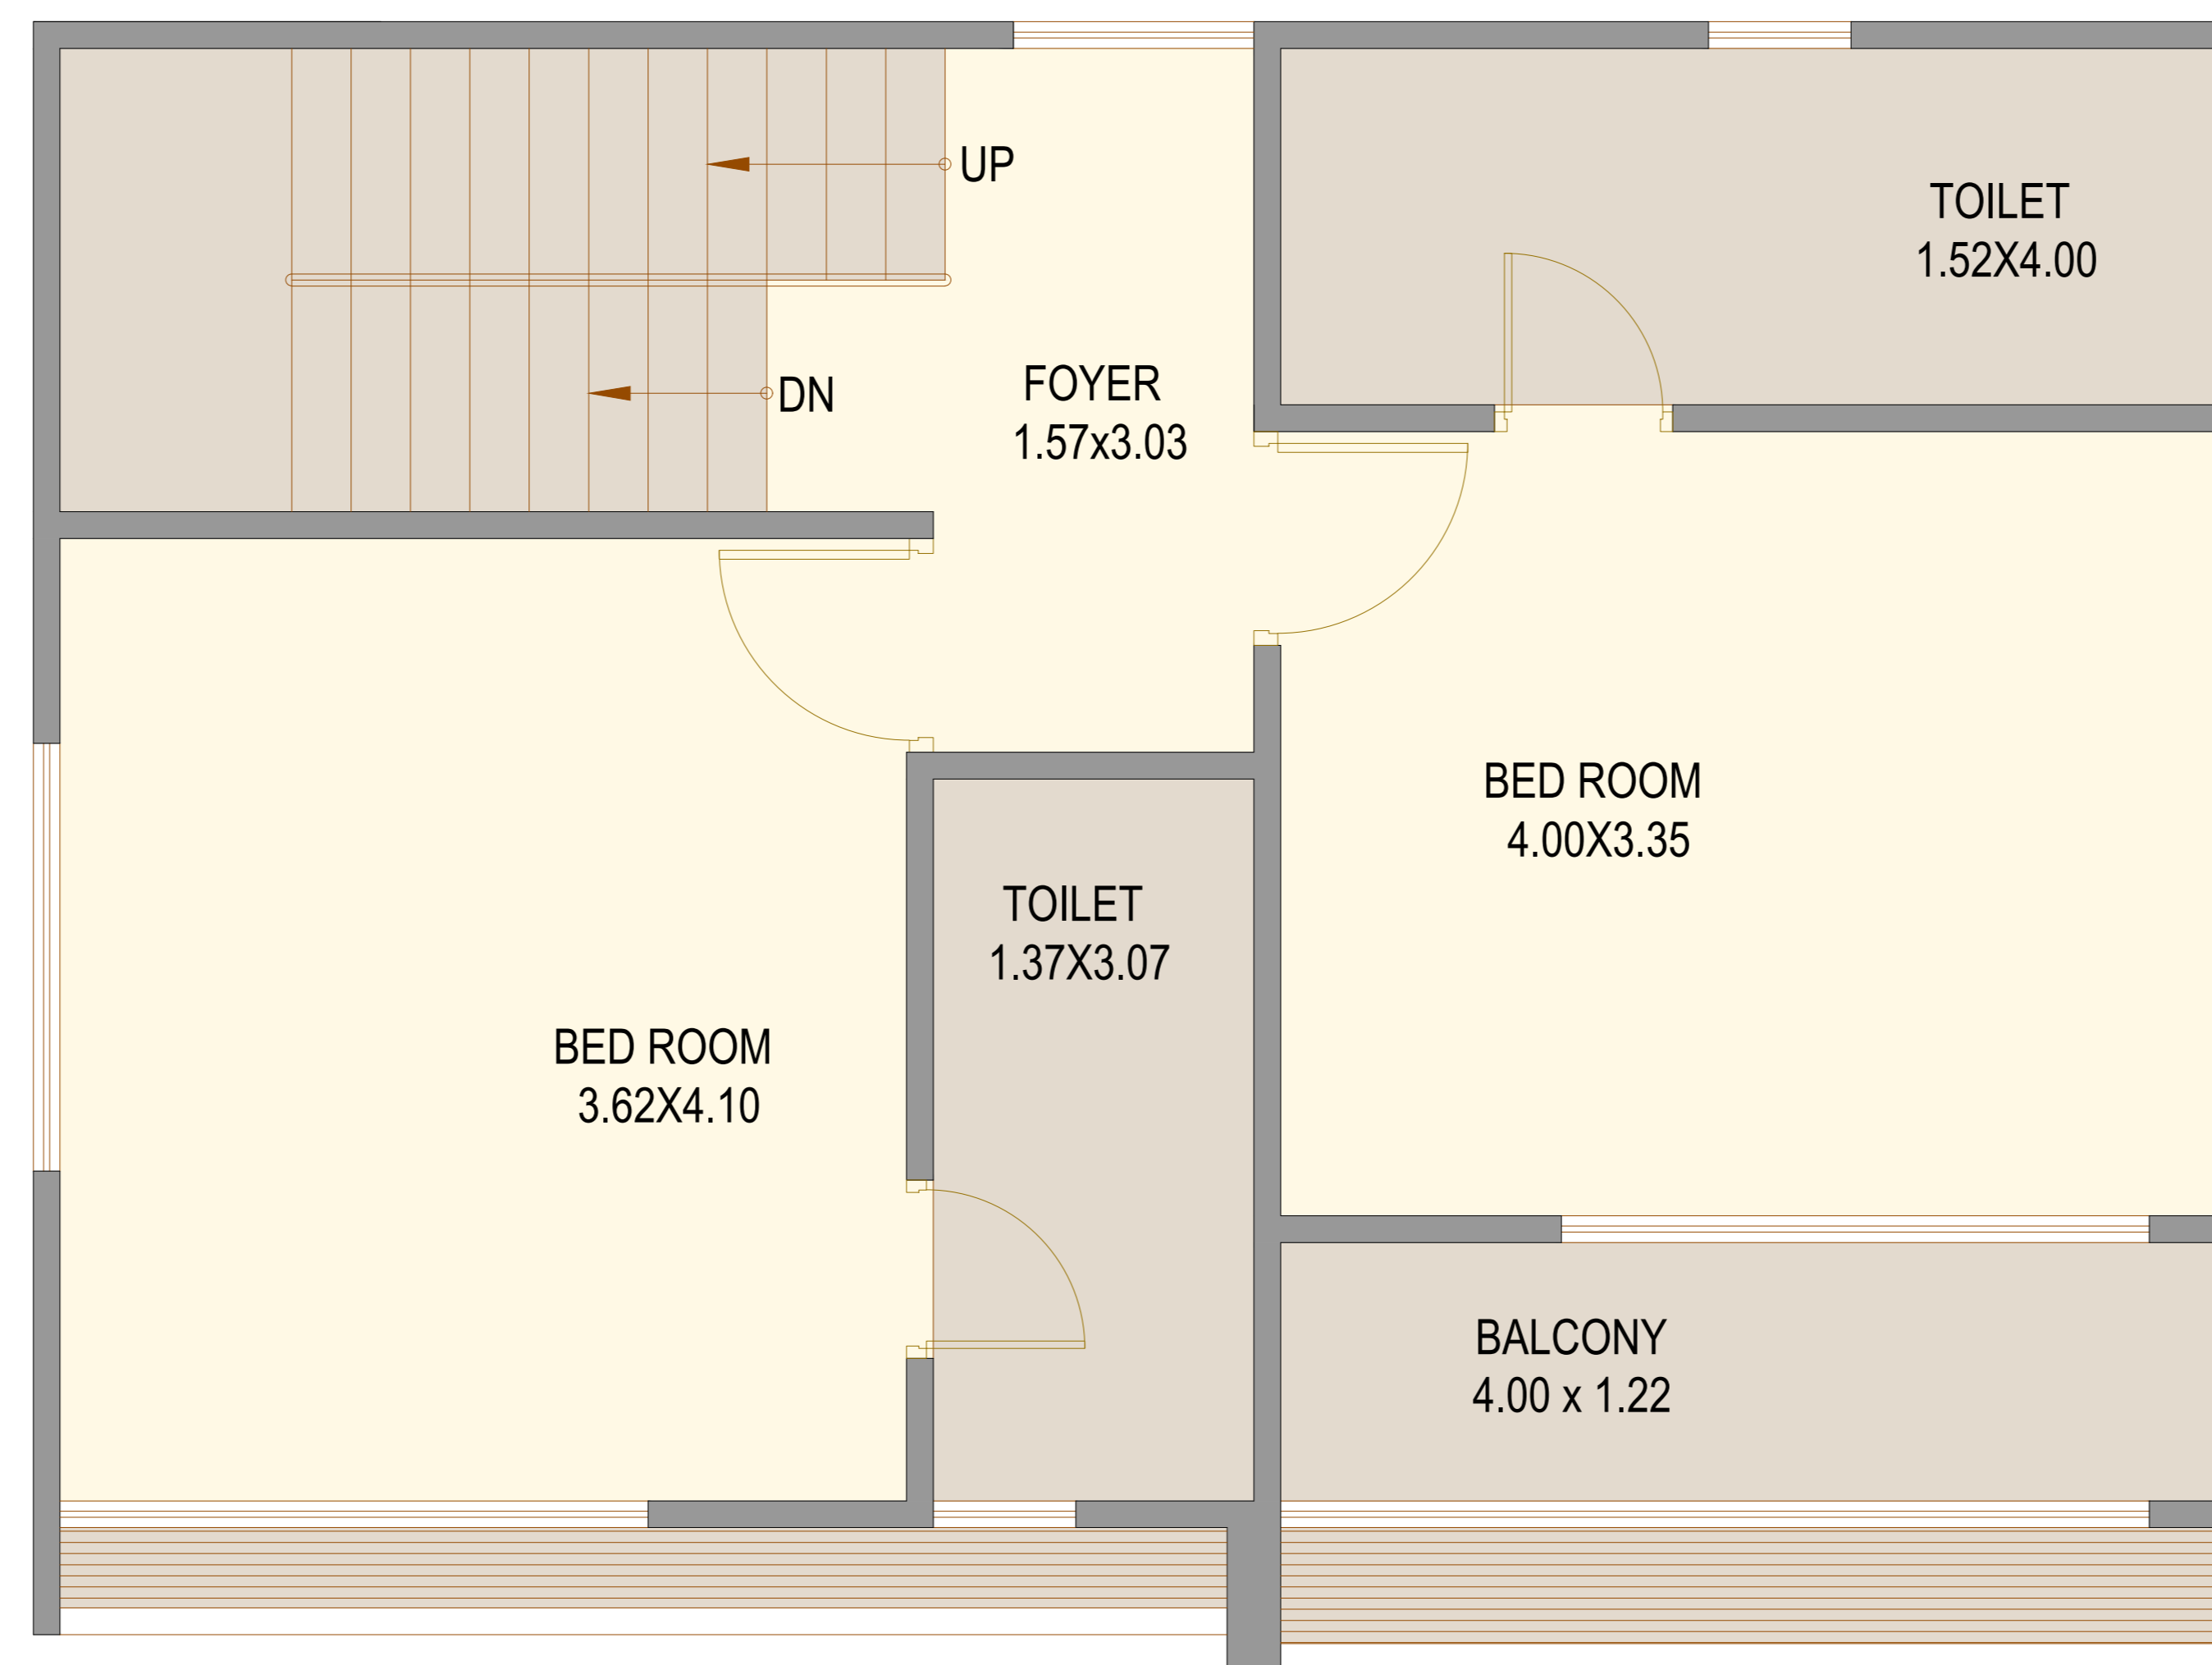

**FIRST FLOOR PLAN**

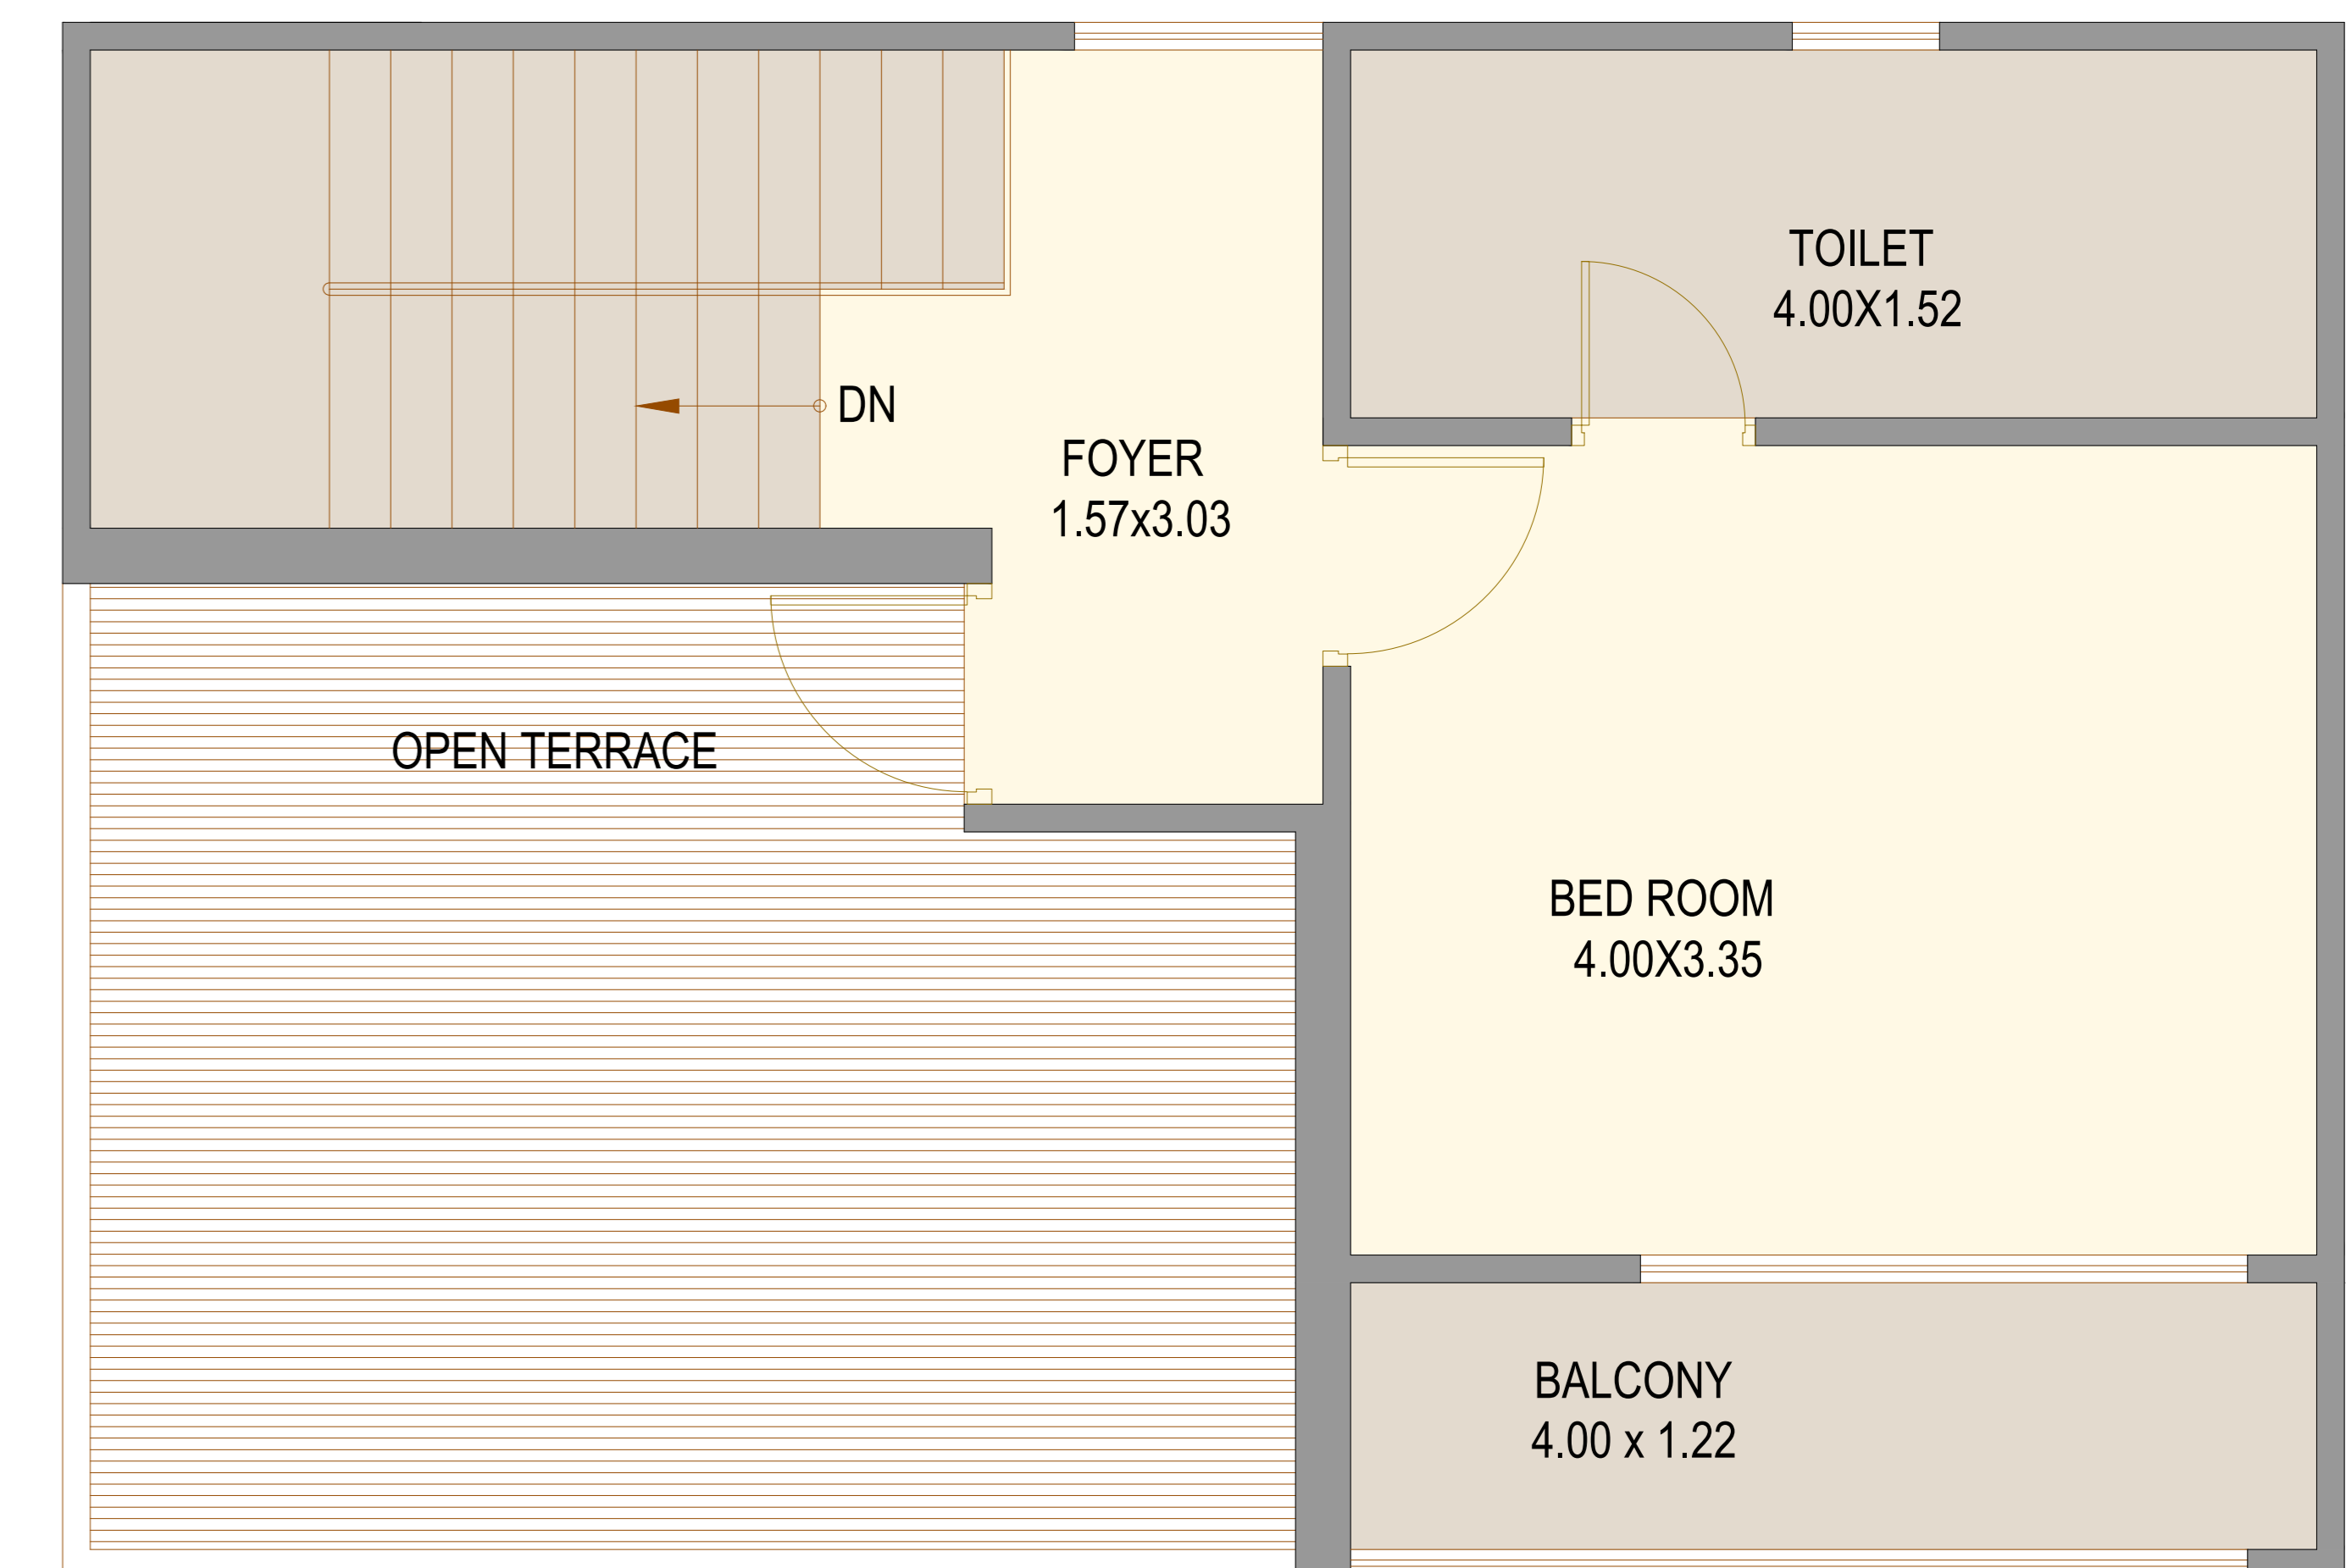

**SECOND FLOOR PLAN**

PROJECT NAME : RAINBOW VILLA'S


DRG. TITLE : FLOOR PLAN

(I-1, J-1)  
(UNIT -18 & 19)

LOCATED

@  
LAMBHA

NORTH LOCATION

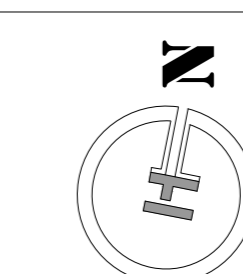

DRG. SCALE

NOT TO SCALE


DATE : 20.01.2023

DRN. BY : PARESH


CHK. BY : VIRAL PATEL

The HAPPY DESIGN


FF-9, SHRINIVAS COMPLEX,  
OPP. VAIBHAV HALL, GHODASAR,  
AHMEDABAD, 380050  
M : +91 98984 34241  
M : +91 76000 99342  
Email: [thappydesign@gmail.com](mailto:thappydesign@gmail.com)  
; [studiothappydesign@gmail.com](mailto:studiothappydesign@gmail.com)  
Web: [www.thehappydesign.in](http://www.thehappydesign.in)

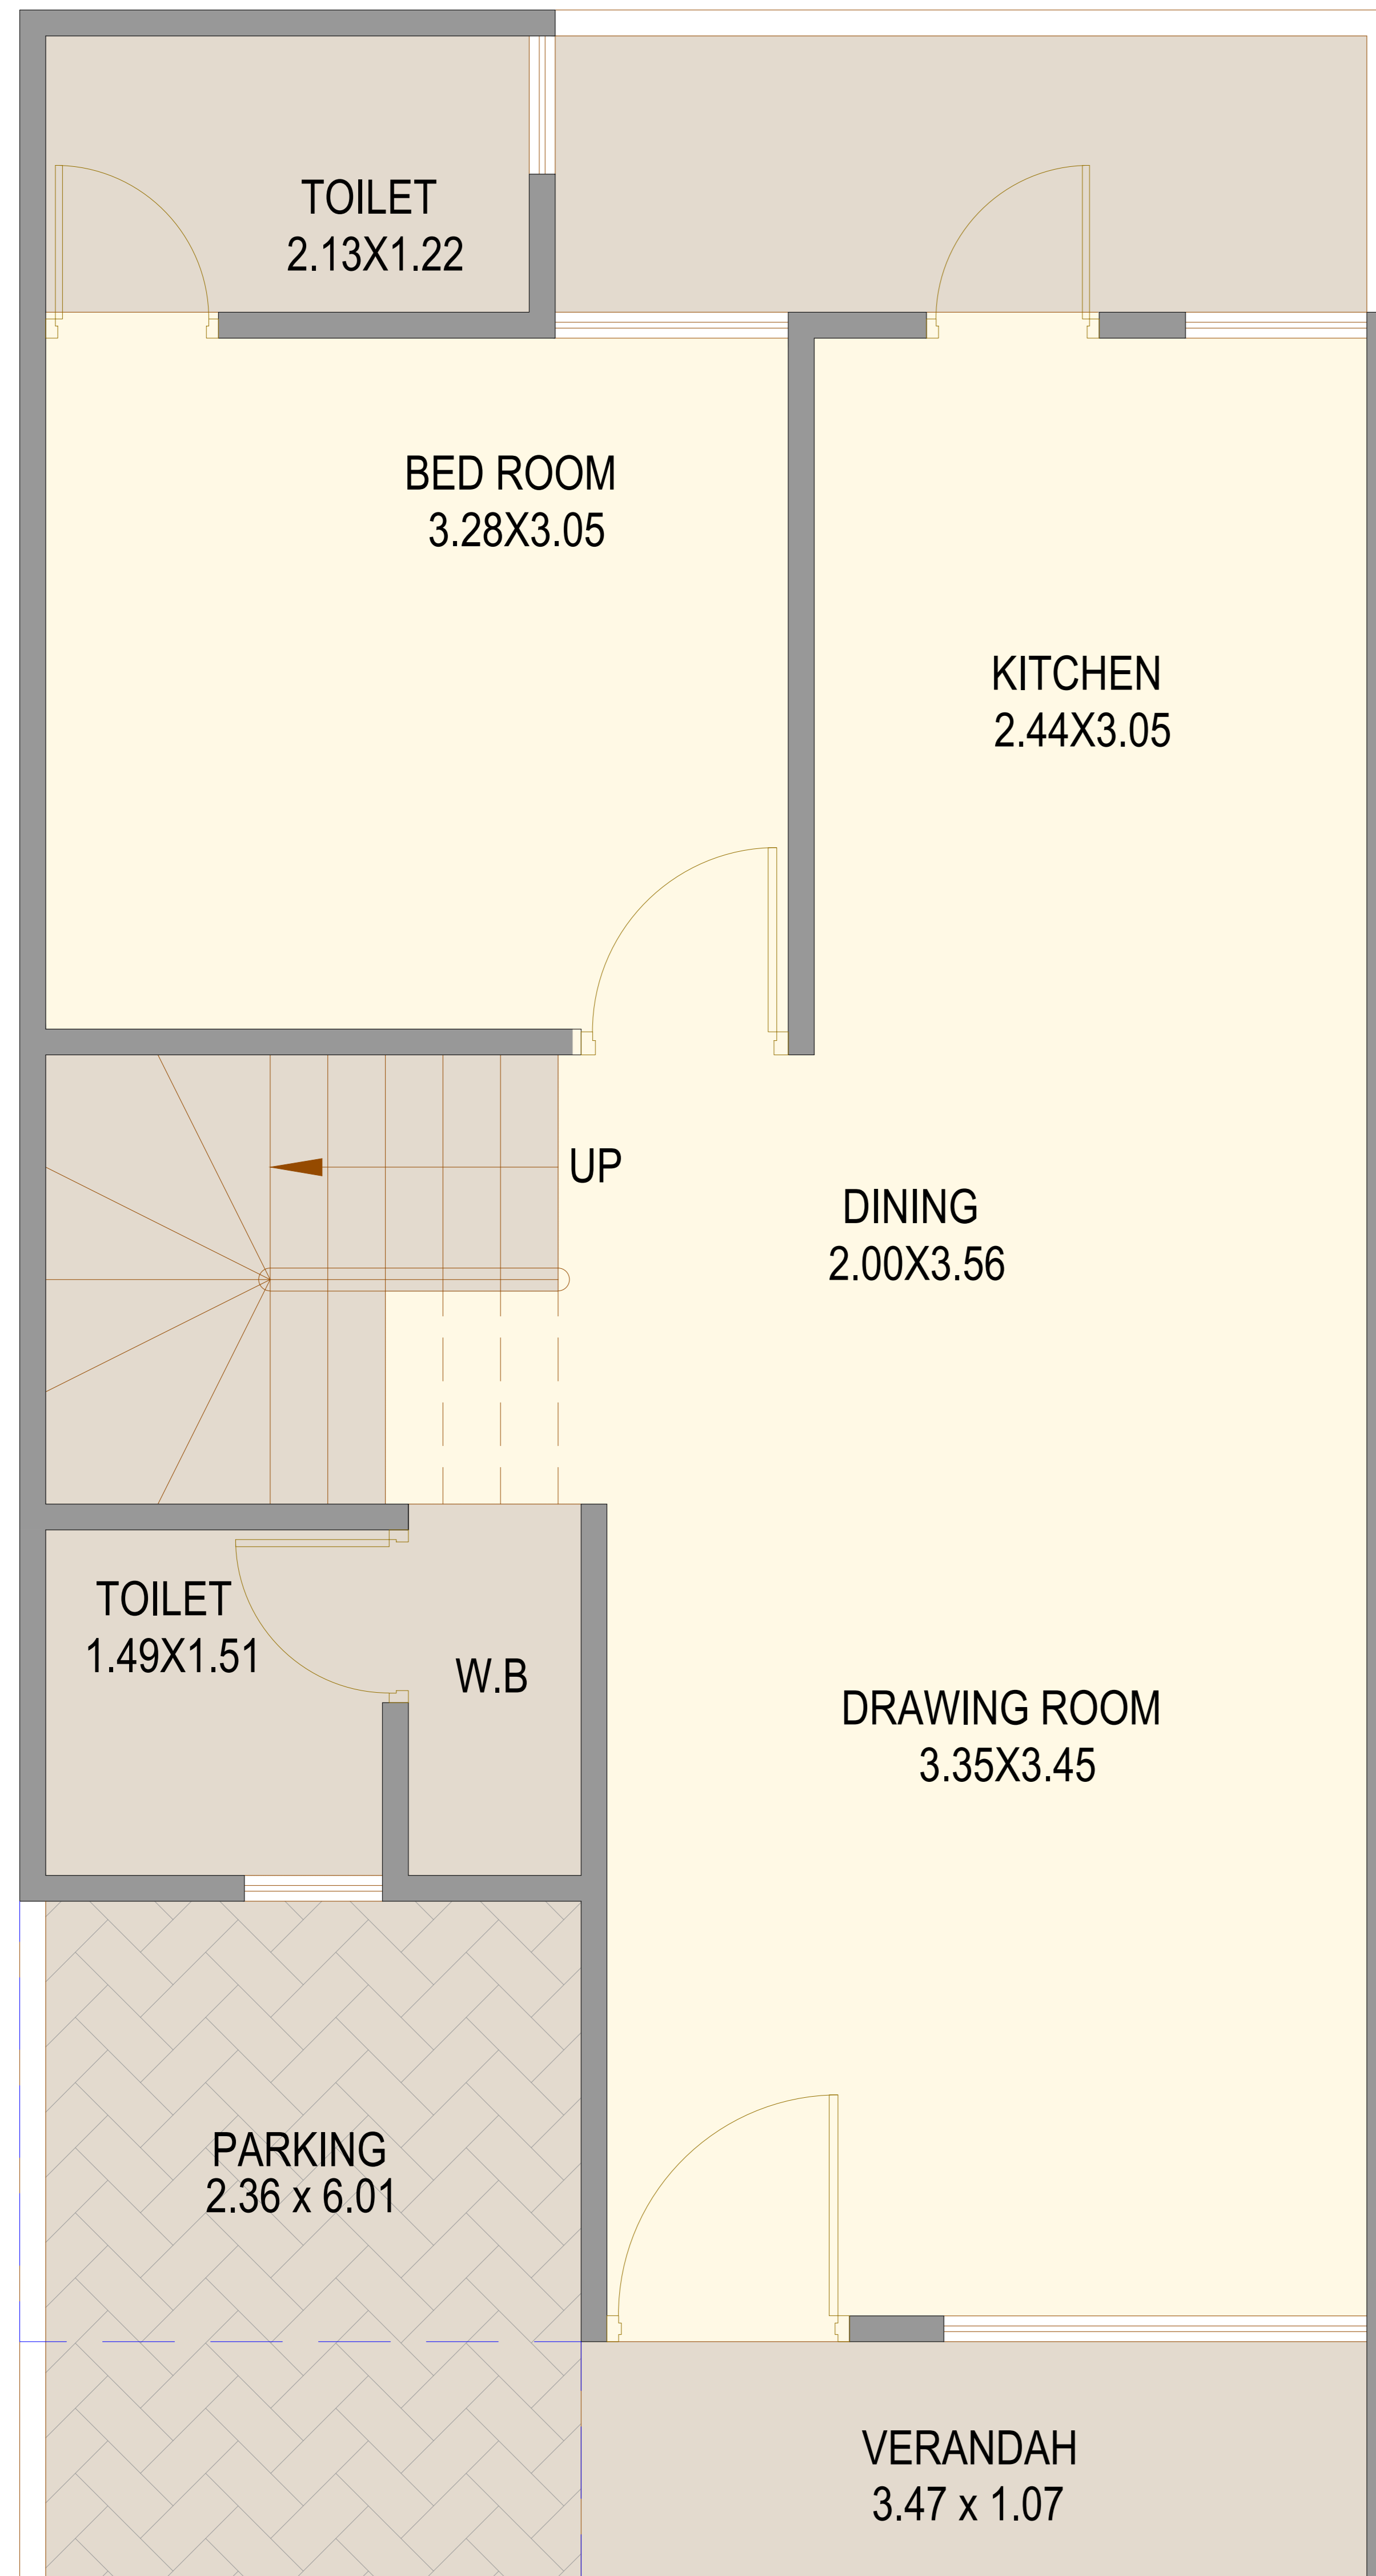

**GROUND FLOOR PLAN**

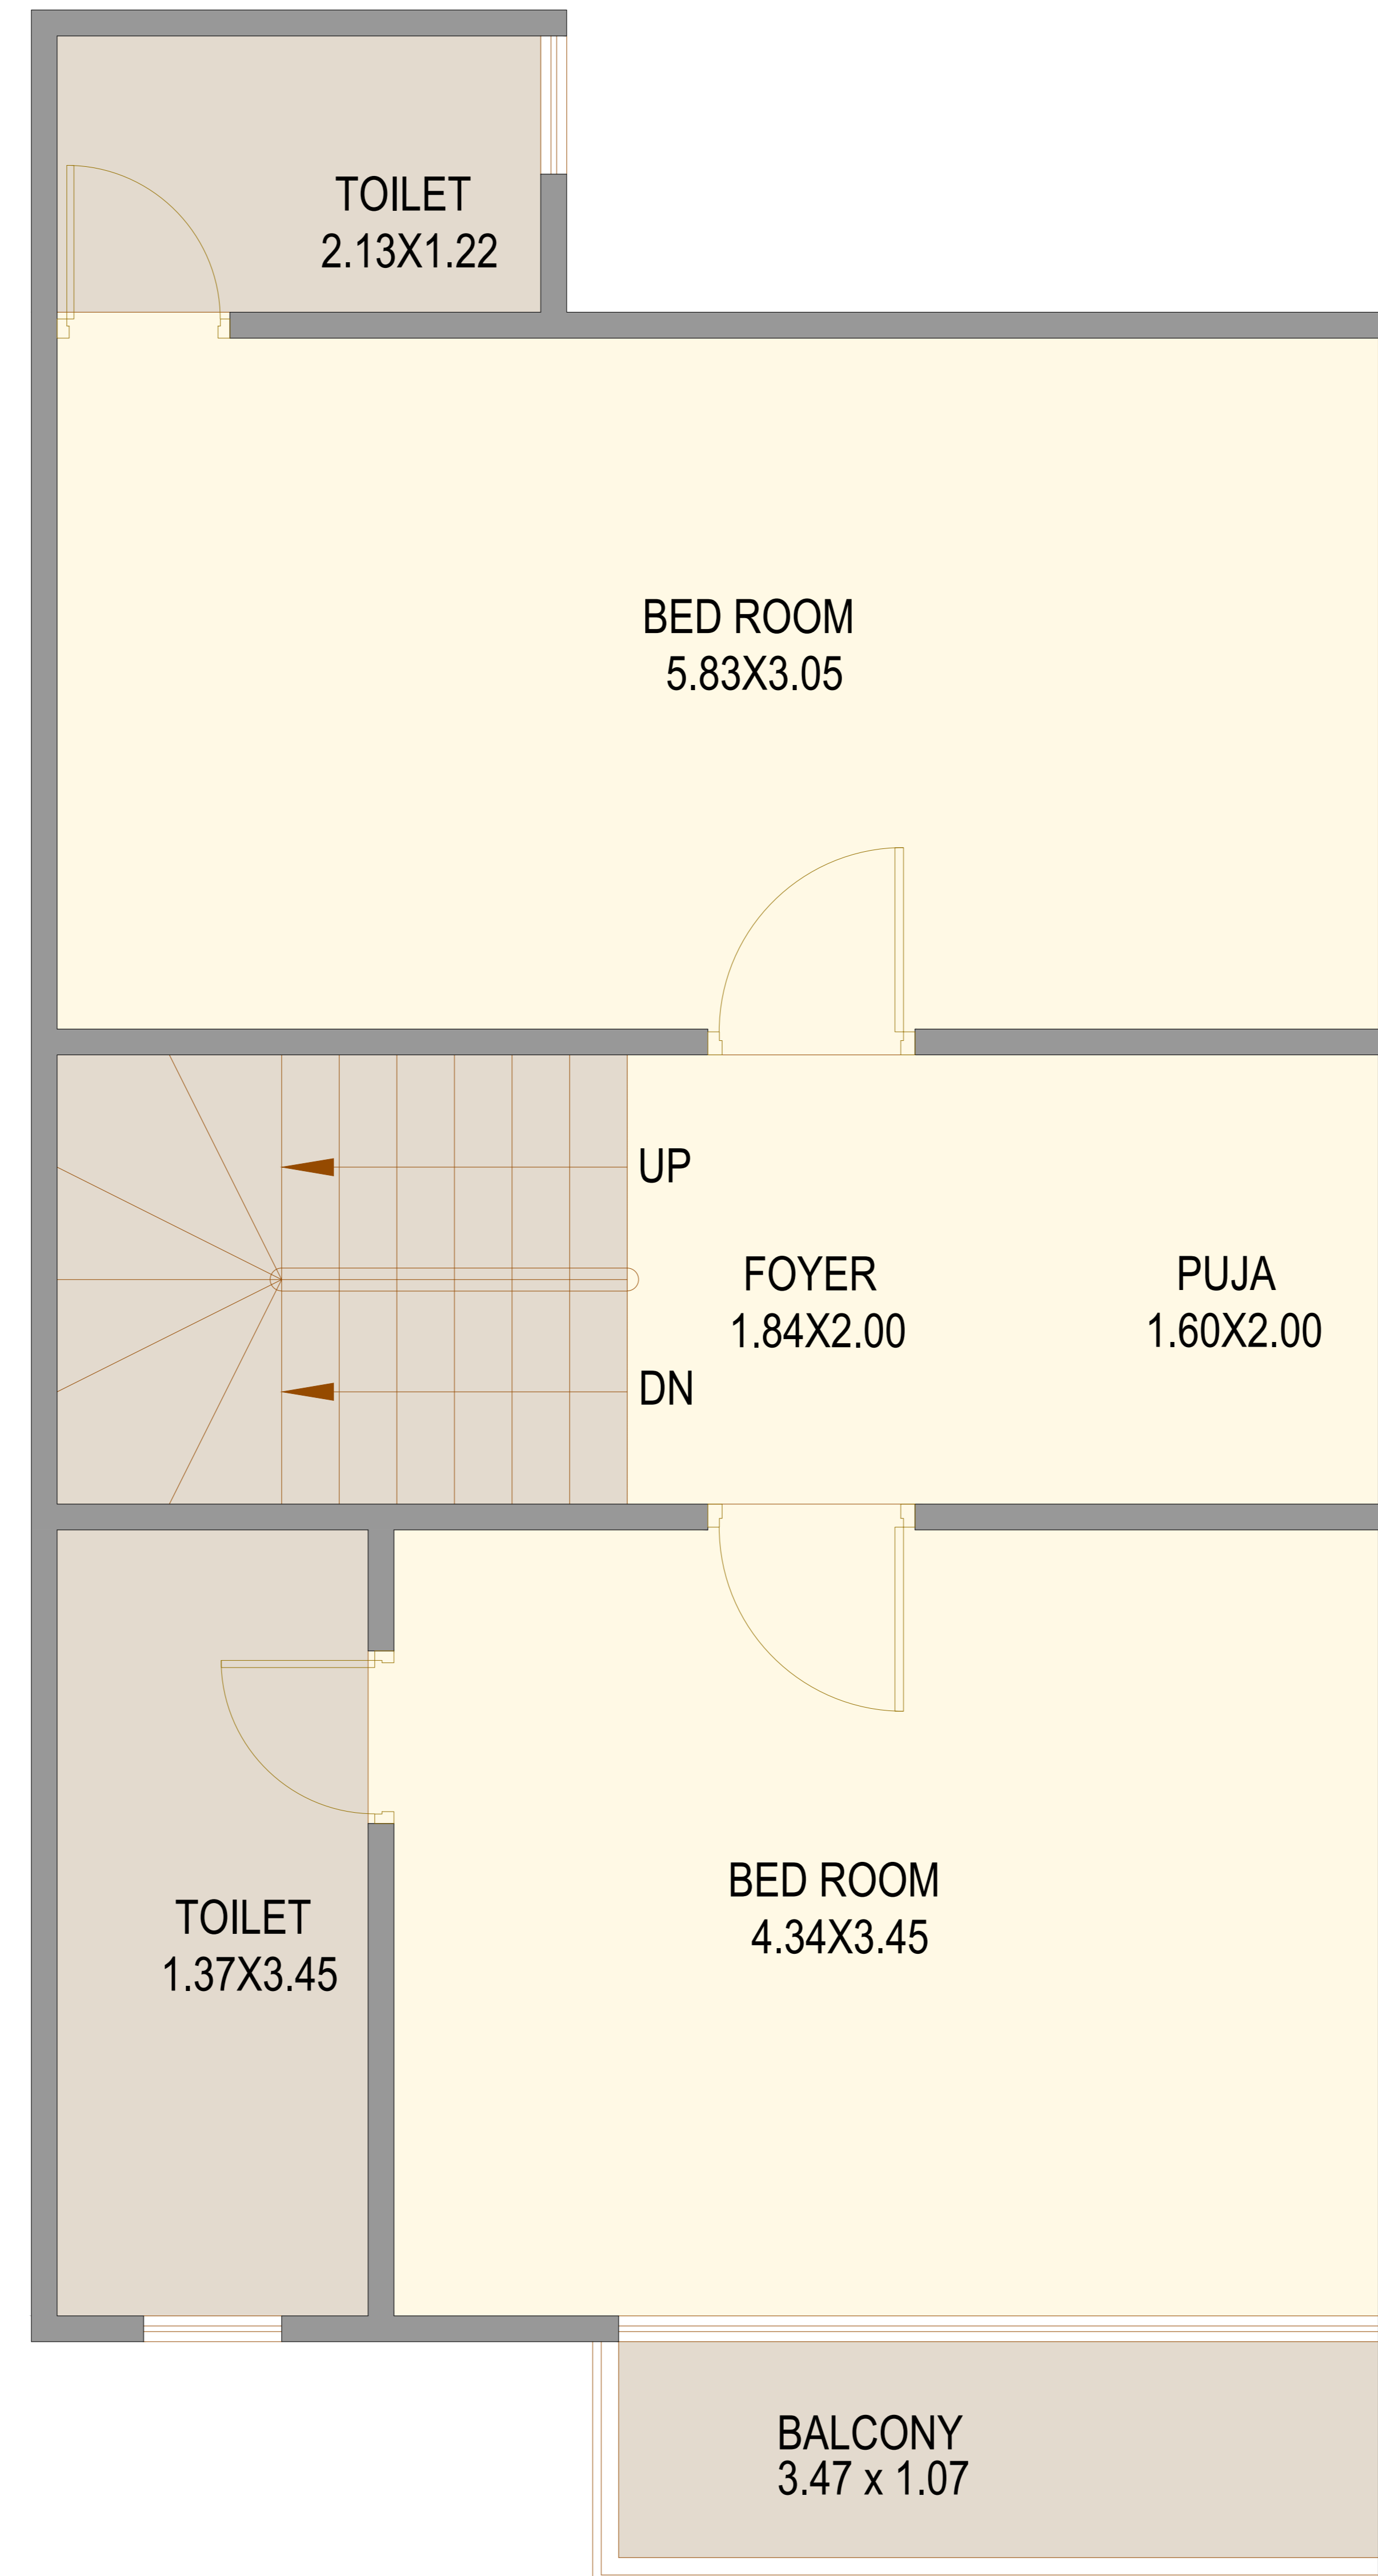

**FIRST FLOOR PLAN**

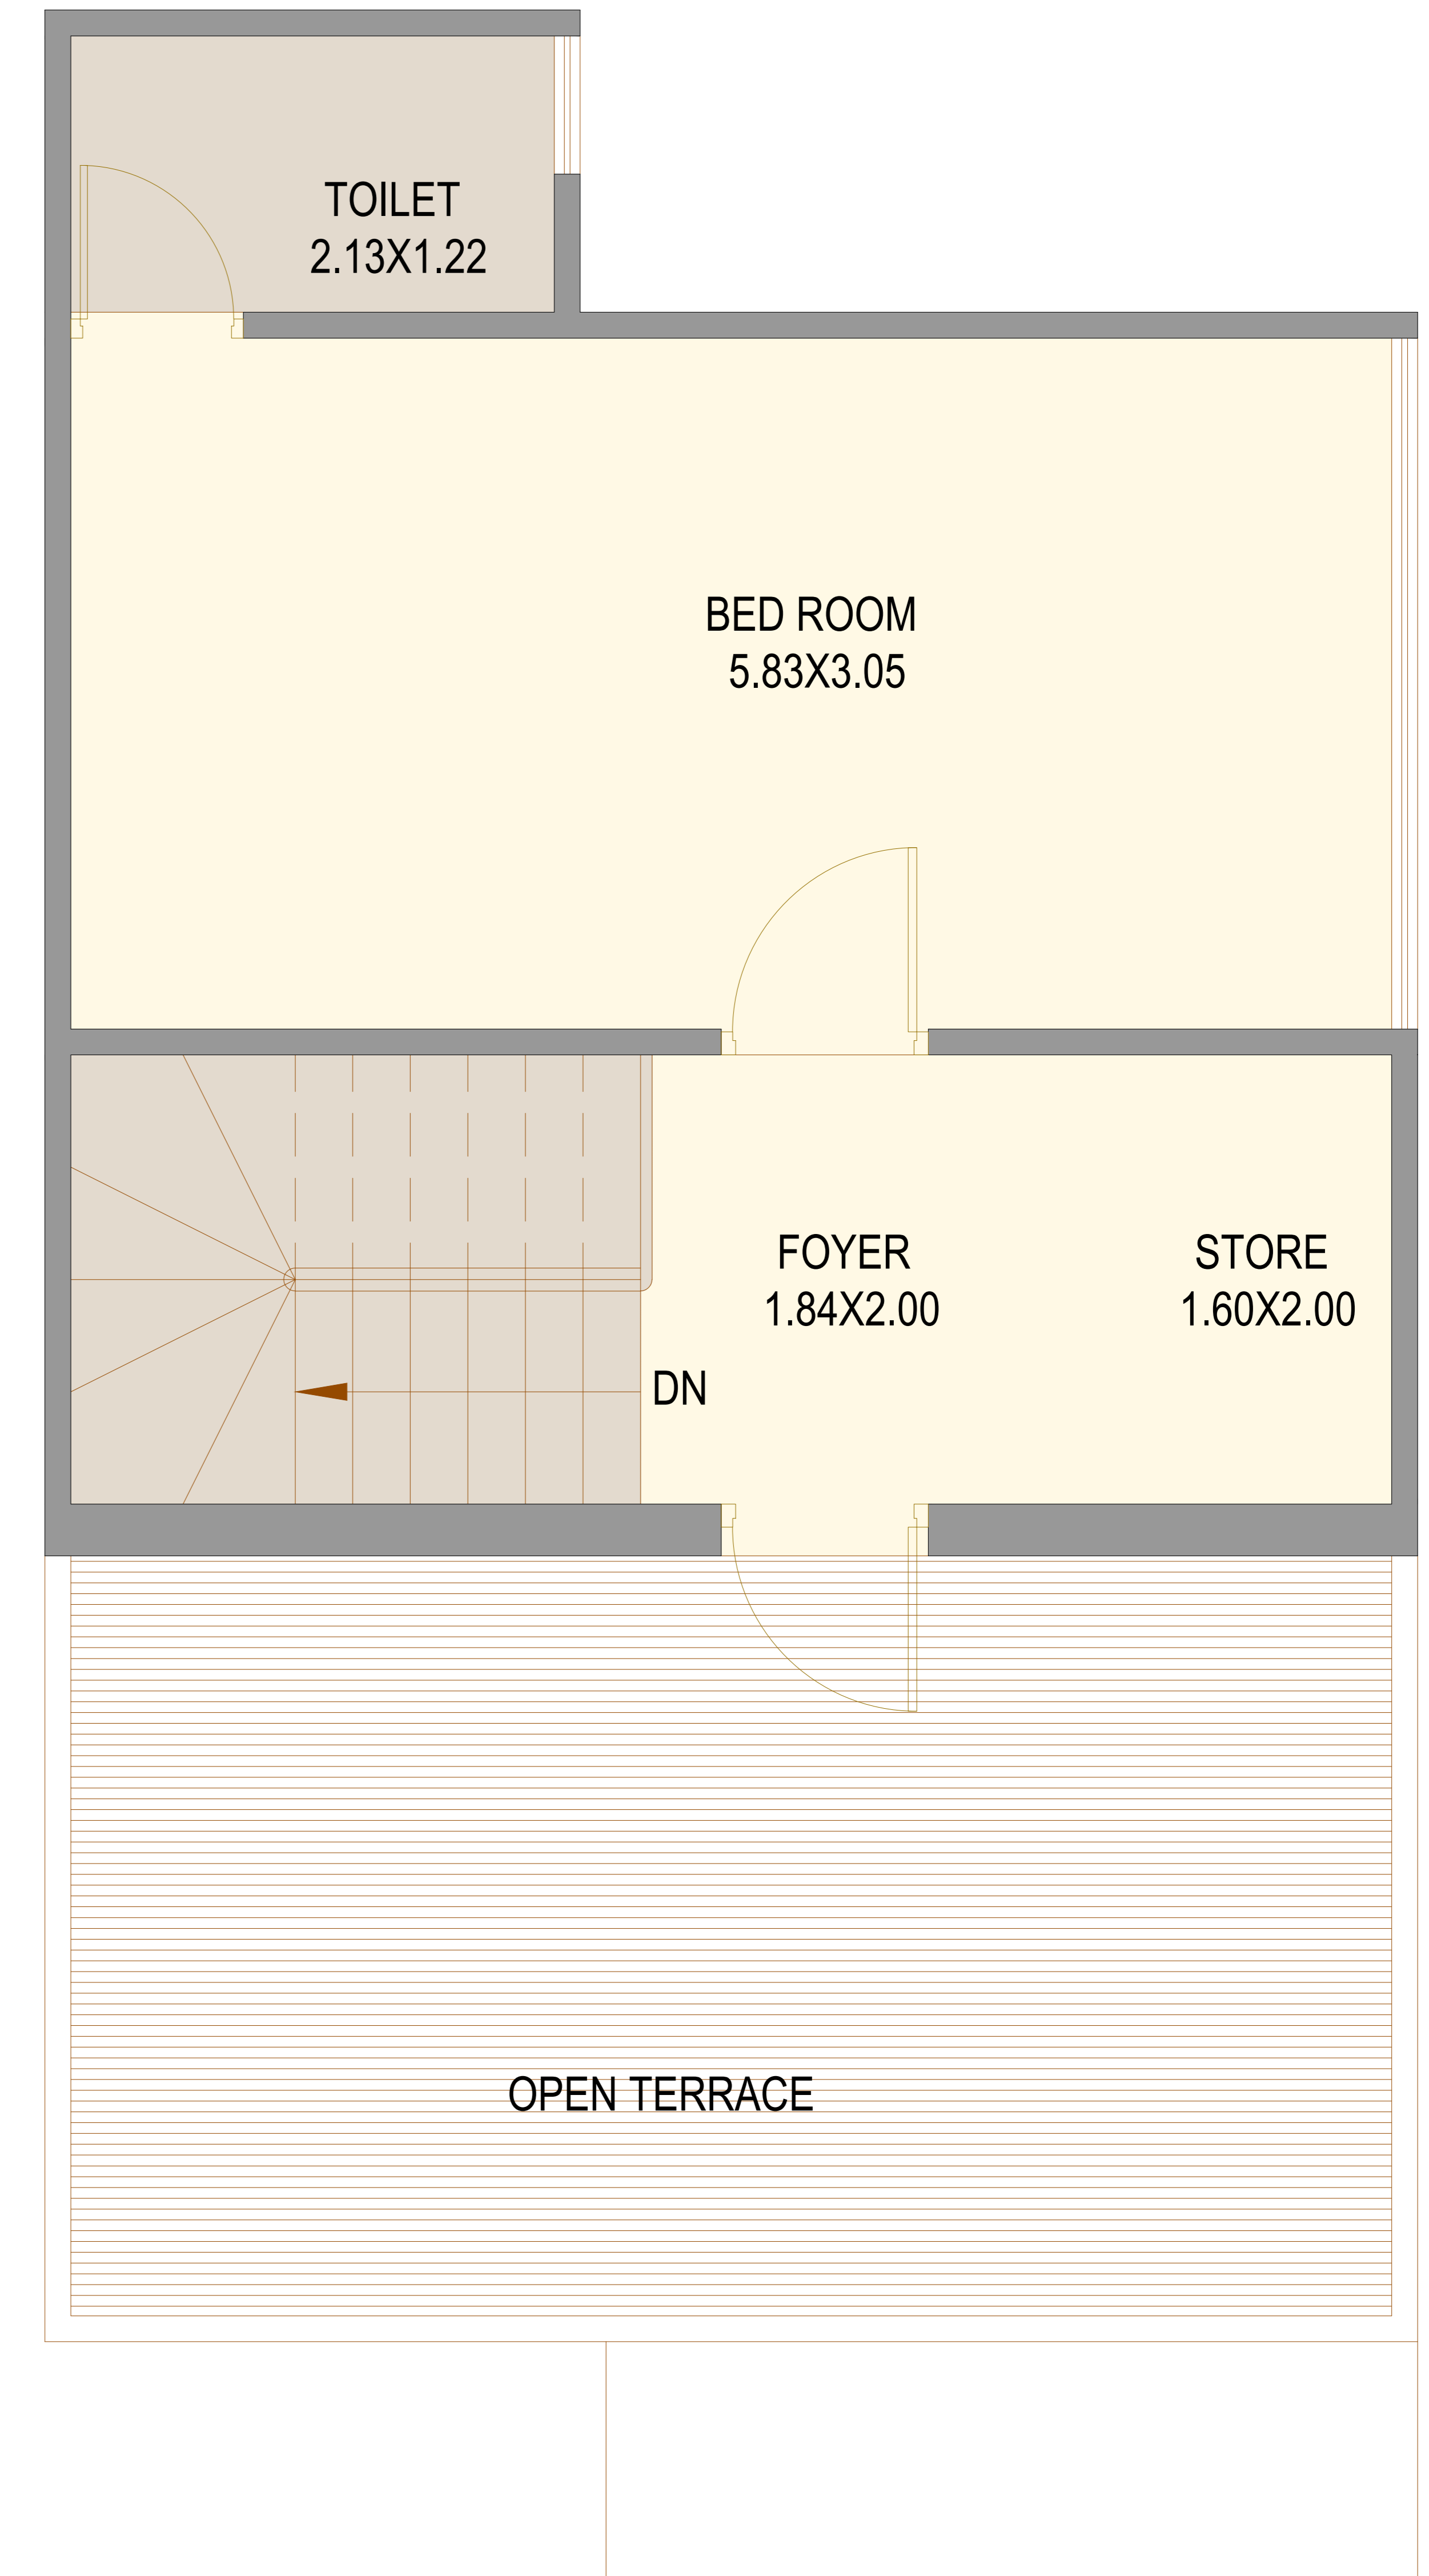

**SECOND FLOOR PLAN**

PROJECT NAME : RAINBOW VILLA'S

DRG. TITLE : FLOOR PLAN

(K-2, L-4, M-4, L-3, M-3, N-2, K-1, L-2, M-2, L-1, M-1, N-1)  
(UNIT -20 TO 31)

LOCATED @ LAMBHA

NORTH LOCATION

DRG. SCALE NOT TO SCALE

DATE : 07.01.2023  
DRN. BY : PARESH  
CHK. BY : VIRAL PATEL

FF-9, SHRINIVAS COMPLEX,  
OPP. VAIBHAV HALL, GHODASAR,  
AHMEDABAD. 380050  
M : +91 98984 34241  
M : +91 76000 99342  
Email: [thappydesign@gmail.com](mailto:thappydesign@gmail.com)  
: [studiothehappydesign@gmail.com](mailto:studiothehappydesign@gmail.com)  
Web: [www.thehappydesign.in](http://www.thehappydesign.in)

# -: SPECIFICATION :-

## **SPECIFICATIONS :**

---

### **STRUCTURE :**

R.C.C. Frame Structure with earthquake resistant design & Block masonry wall.

---

### **PLASTER :**

Internal Smooth plaster with putty finish, External double coat plaster and Texture design with acrylic colour

---

**FLOORING :** Vitrified tiles.

---

### **KITCHEN :**

Granite platform with S.S.Sink, Vitrified tiles flooring & Title up to beam bottom level

---

### **DOOR & WINDOWS :**

Decorative main door & all other flush door with side laminate. both side laminate. Standard quality for all doors Fully glazed aluminum Domel windows.

---

### **TOILET :**

Best quality sanitary fitting with plumbing fixture from standard make & Designer superior

---

### **ELECTRICAL :**

All electrical multi Strength copper wiring is concealed with PVC insulation wires & modular switches. Sufficient power outlets and light points provided & TV point in Drawing room.

---

### **WATER :**

Bore with underground and overhead water tank with sufficient capacity.

---

**TERRACE :** China mosaic flooring.

## **RAINBOW VILLA'S**

**ADDRESS :- Rainbow Villa's, Beside Bhagirath South Park,  
Lambha 382405 Ahmedabad**

**For Booking :- 9714447173**